


List of working drawings	
Sheet Number	Sheet Name
A100	Project Information
A101	Construction plan
A102	Installation plan
A103	Measurement plan
A104	Furniture layout
A105	Plumbing plan
A106	Floor finish plan
A107	Ceiling finish plan
A108	Lighting plan
A109	Lighting groups plan
A110	Sockets & electrical output layout
A112	Wall finish plan
A113	Marking plan
A114	Wall elevations
A115	Wall elevations
A116	Wall elevations
A117	Wall elevations
A118	Wall elevations
A119	Specifications
A120	Specifications
A121	Specifications
A122	Specifications
A123	Specifications

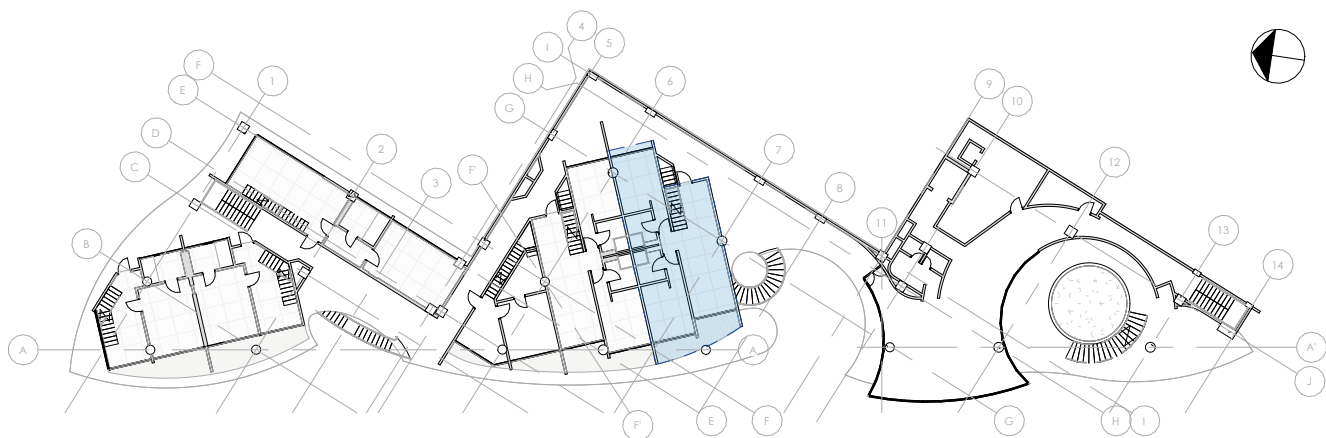

Key Plan Pent #2

1 : 500

Notes:

1. It is allowed to make changes to the Design project during the implementation process, subject to agreement with the architect.

2.The visualizations in this album are a conditional indicative image of the finished object and should be considered together with the drawings and equipment.

3.Non-standard structures, complex elements and structural units are developed by the relevant contractor on the basis of the technical specifications issued by the architect

MELASTI ARCADE

Sheet name
Project Information


Scale
1 : 500

Sheet
A100

SNAAR

Construction

1 : 50

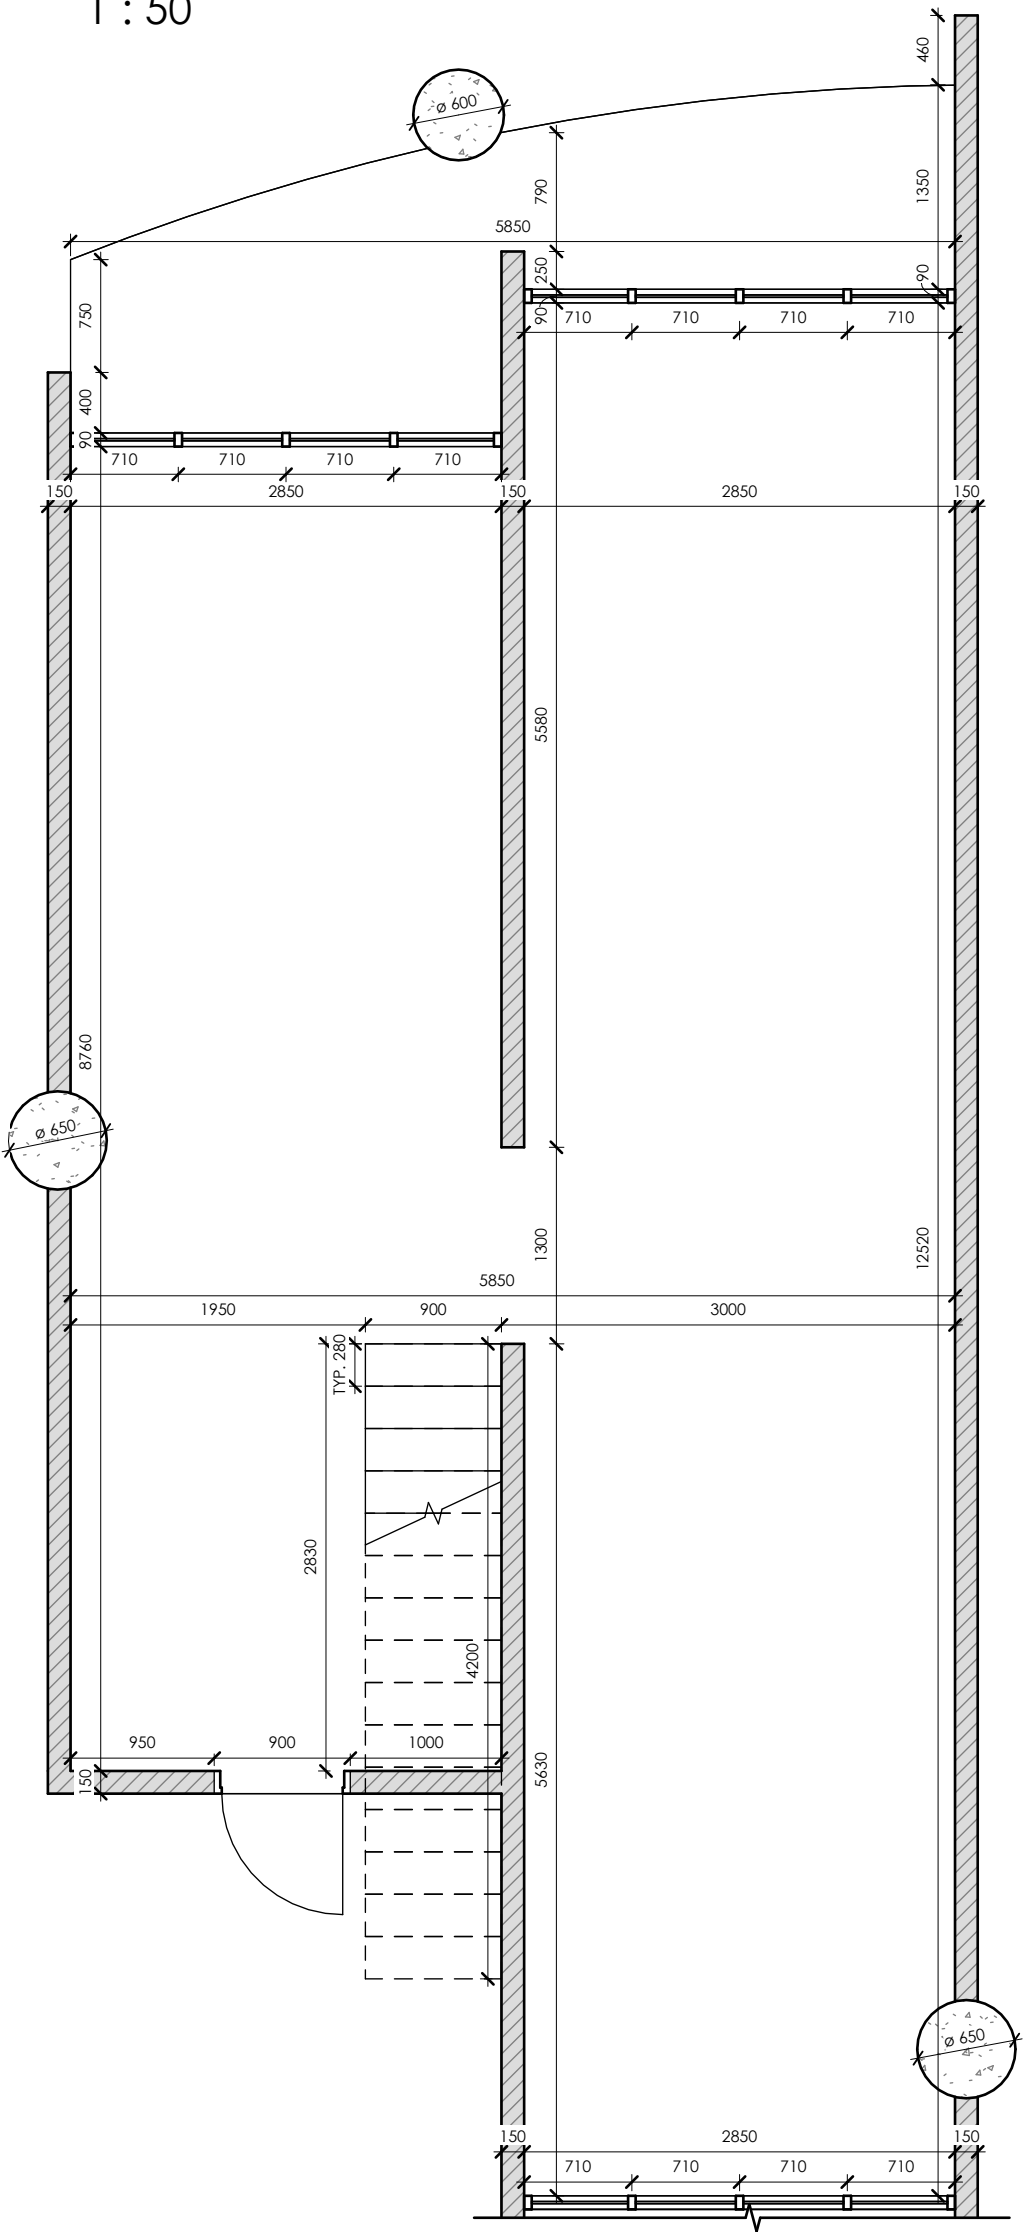

- Notes:
1. All dimensions are design. Before ordering, manufacturing, installation, it is imperative to perform actual measurements.
 2. The color and texture of the materials are agreed only on real samples.
 3. In case of changes in dimensions or position in space, coordinate with the project architect.

MELASTI ARCADE

Sheet name
Construction plan


Scale
1 : 50

Sheet
A101

SNAAR

Installation

1 : 50

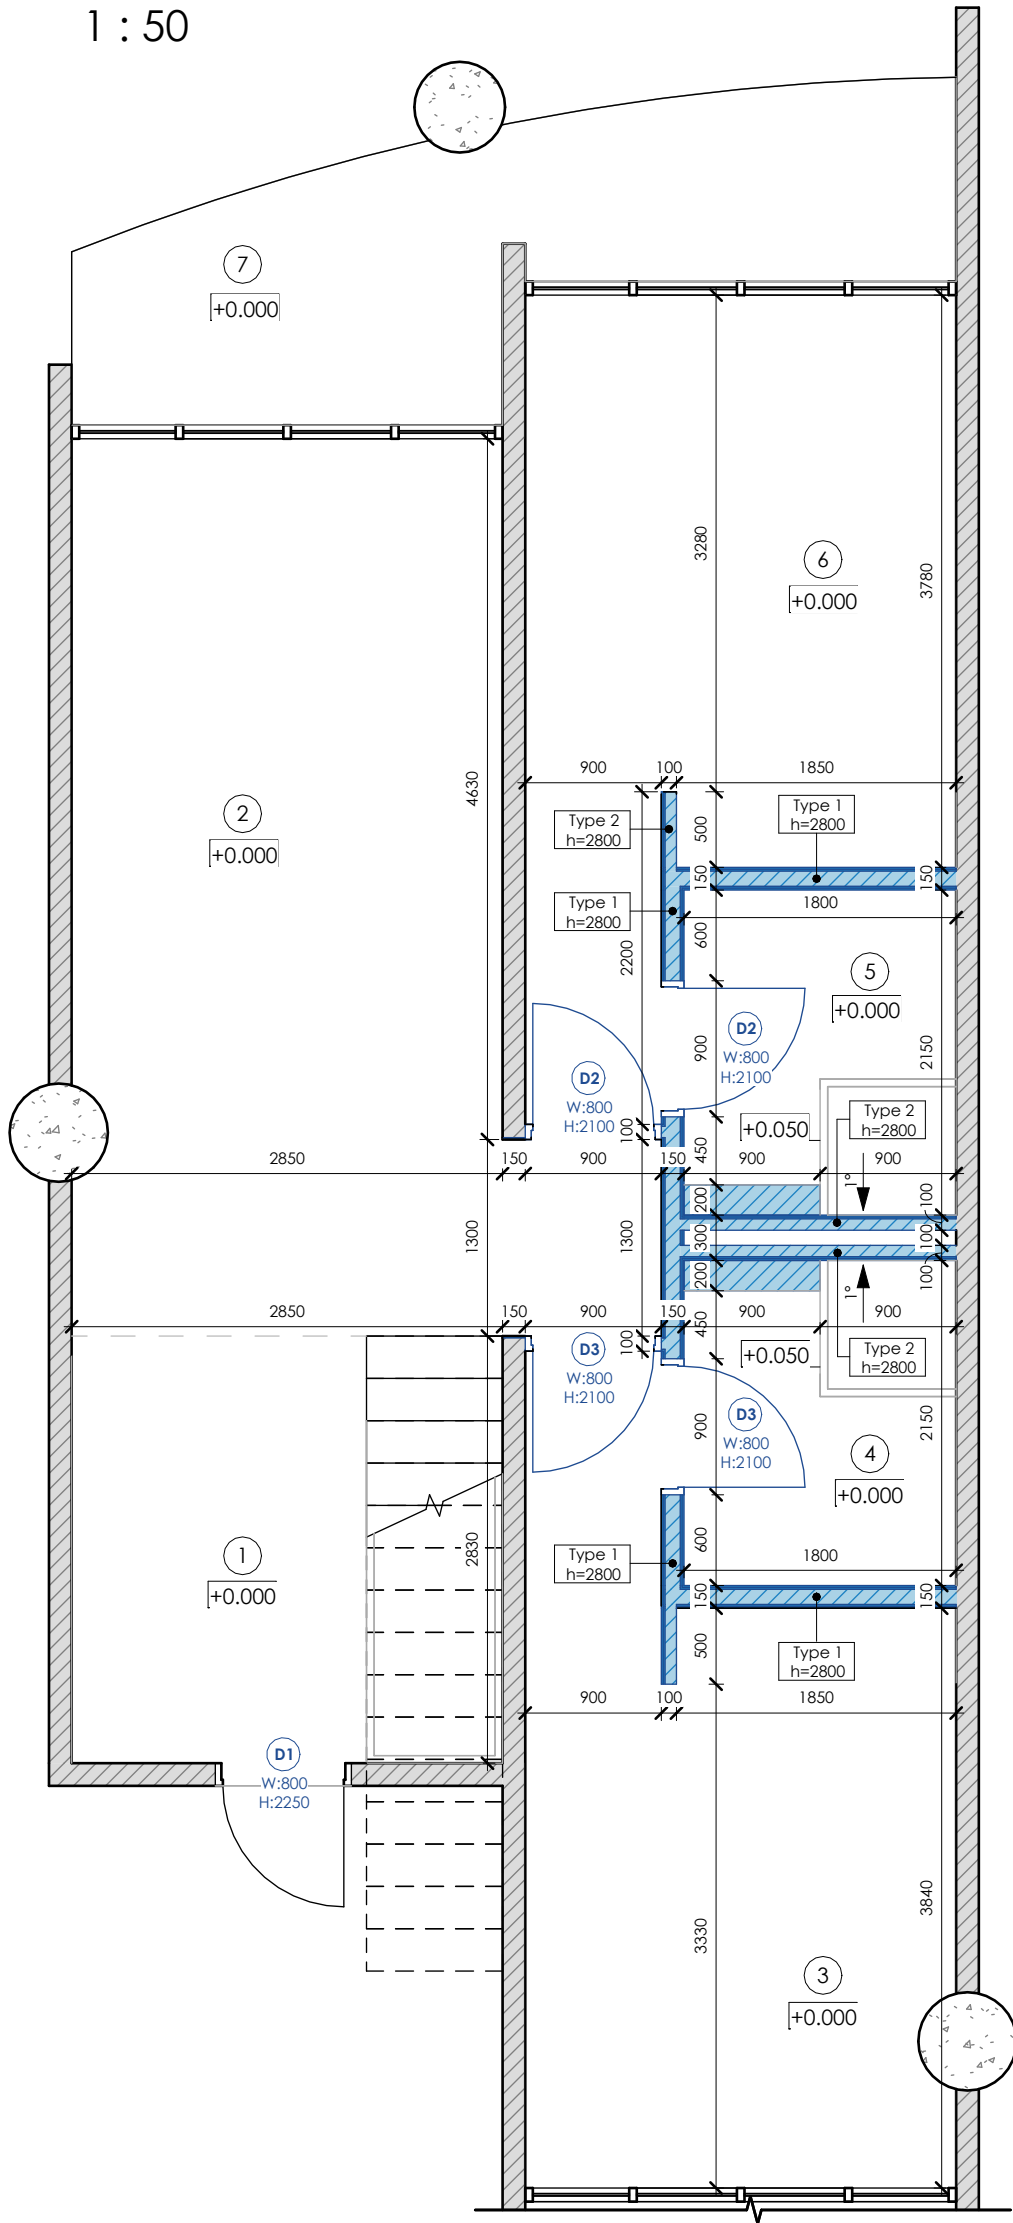

Room Schedule		
Nº	Name	Area
Level 3		
1	Kitchen	8.1 m²
2	Living room	18.1 m²
3	Bedroom	12.2 m²
4	Bathroom	3.9 m²
5	Bathroom	3.9 m²
6	Bedroom	12.2 m²
7	Terrace	8.1 m²
		66.4 m²
Roof top		
8	Roof top	78.6 m²
		78.6 m²
Total area:		144.9 m²

Notes:

1. All dimensions are design. Before ordering, manufacturing, installation, it is imperative to perform actual measurements.
2. The color and texture of the materials are agreed only on real samples.
3. In case of changes in dimensions or position in space, coordinate with the project architect.

Wall Schedule				
Mark	On the plan	Description	Thickness	Volume
Type 1		Aluminium profile 125mm - Drywall 12.5mm, 2 sheet, two sides	150 mm	3.05 m³
Type 2		Aluminium profile 75mm - Drywall 12.5mm, 2 sheet, one side	100 mm	1.45 m³

Door Schedule					
Mark	Count	Description	Opening type	Finish inside	Finish outside
D1	1	Concealed installation door 800x2250mm (clear canvas)	Right hand/outside	Decorative plaster (grey)	-
D2	2	Concealed installation door 800x2100mm (clear canvas)	Left hand/inside	Decorative plaster (grey)	Decorative plaster (grey)/MDF panel (dark wood)
D3	2	Concealed installation door 800x2100mm (clear canvas)	Right hand/inside	Decorative plaster (grey)	Decorative plaster (grey)/MDF panel (dark wood)

MELASTI ARCADE

Sheet name
Installation plan


Scale
1 : 50

Sheet
A102

SNAAR

Measurement

1 : 50

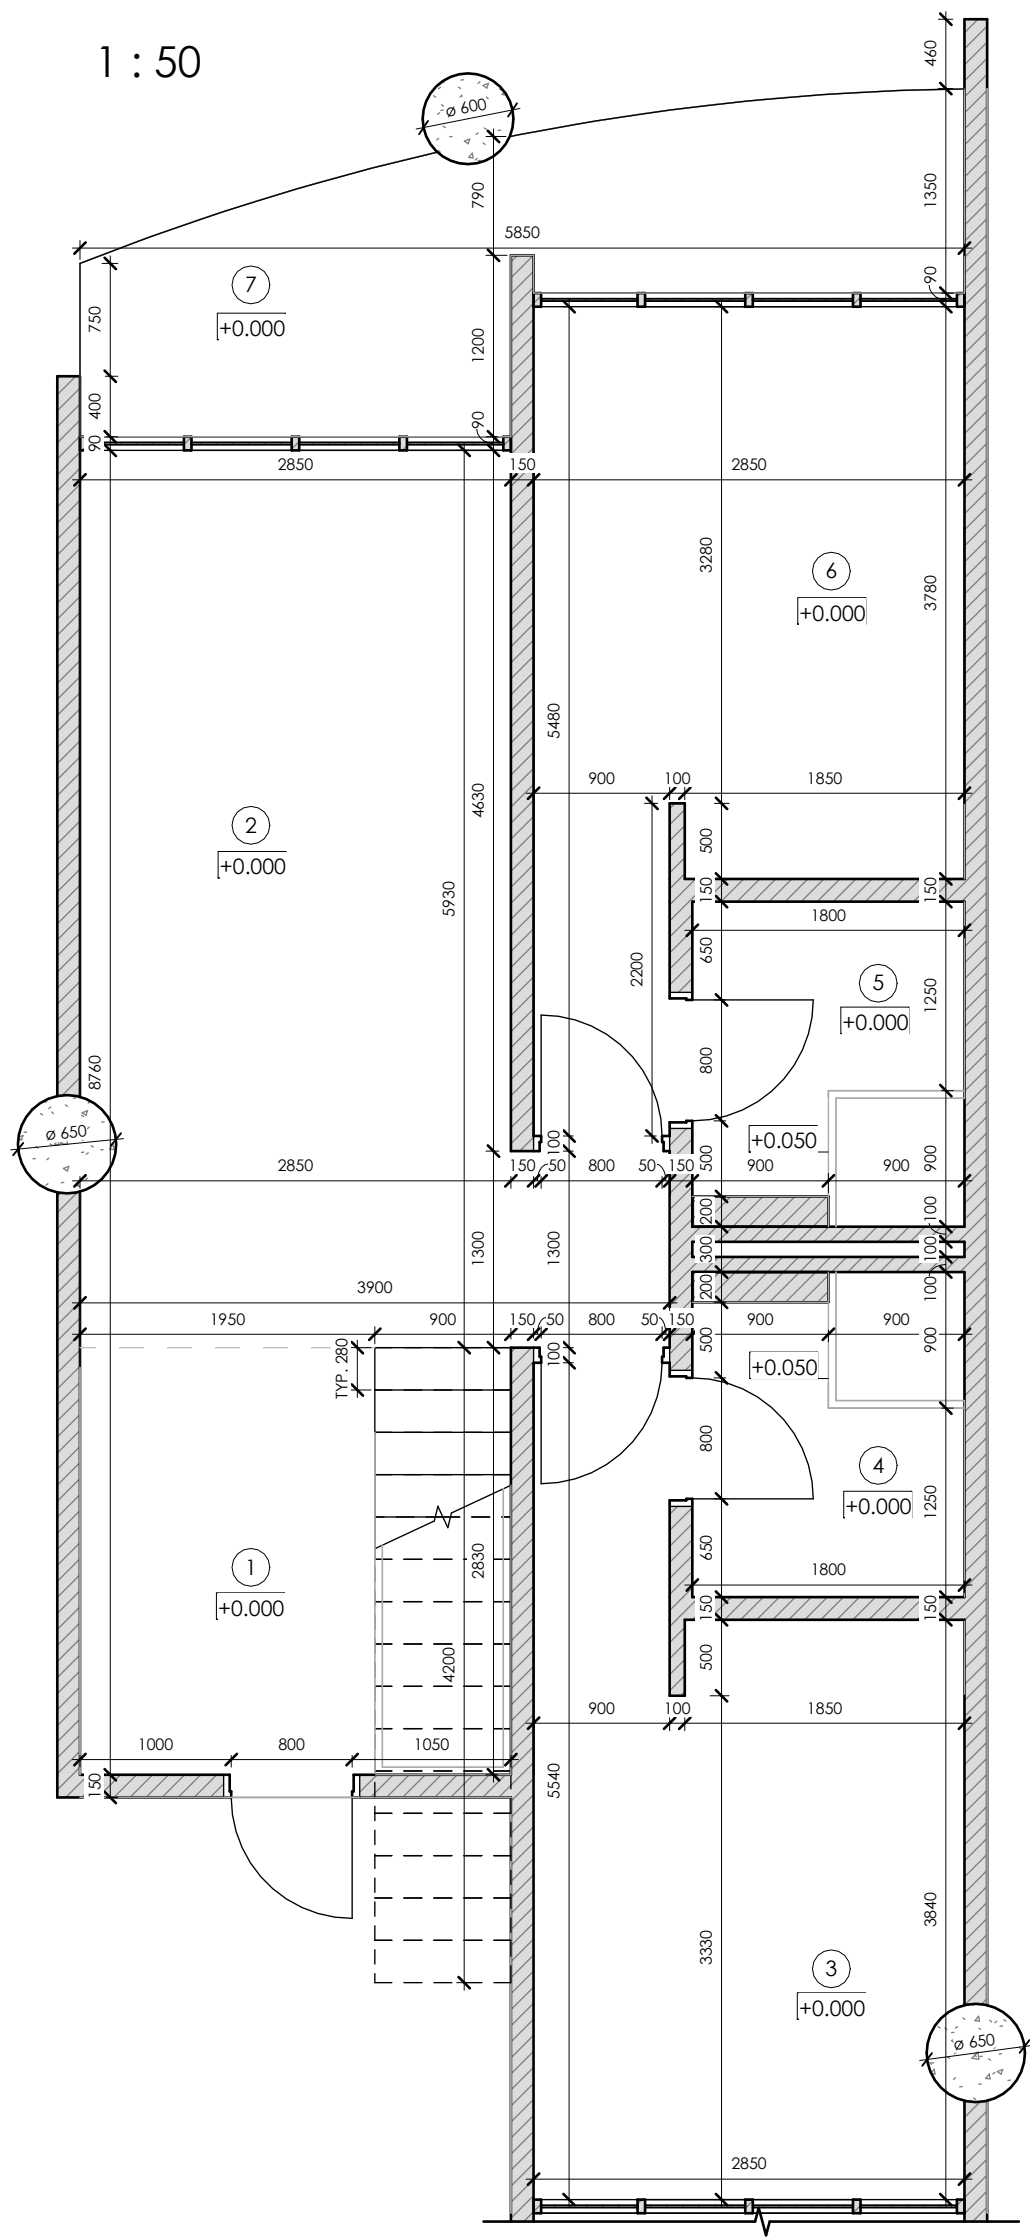

Room Schedule		
Nº	Name	Area
Level 3		
1	Kitchen	8.1 m²
2	Living room	18.1 m²
3	Bedroom	12.2 m²
4	Bathroom	3.9 m²
5	Bathroom	3.9 m²
6	Bedroom	12.2 m²
7	Terrace	8.1 m²
		66.4 m²
Roof top		
8	Roof top	78.6 m²
		78.6 m²
Total area:		144.9 m²

- Notes:
1. The contractor develops detailed drawings and coordinates the content and dimensions with the architect of the project.
 2. All dimensions are design. Before ordering, manufacturing, installation of furniture, it is imperative to perform actual measurements.
 3. The color and texture of the materials are agreed only on real samples.
 4. In case of changes in dimensions or position in space, coordinate with the project architect.

MELASTI ARCADE

Sheet name
Measurement plan


Scale
1 : 50

Sheet
A103

SNAAR

Furniture

1 : 50

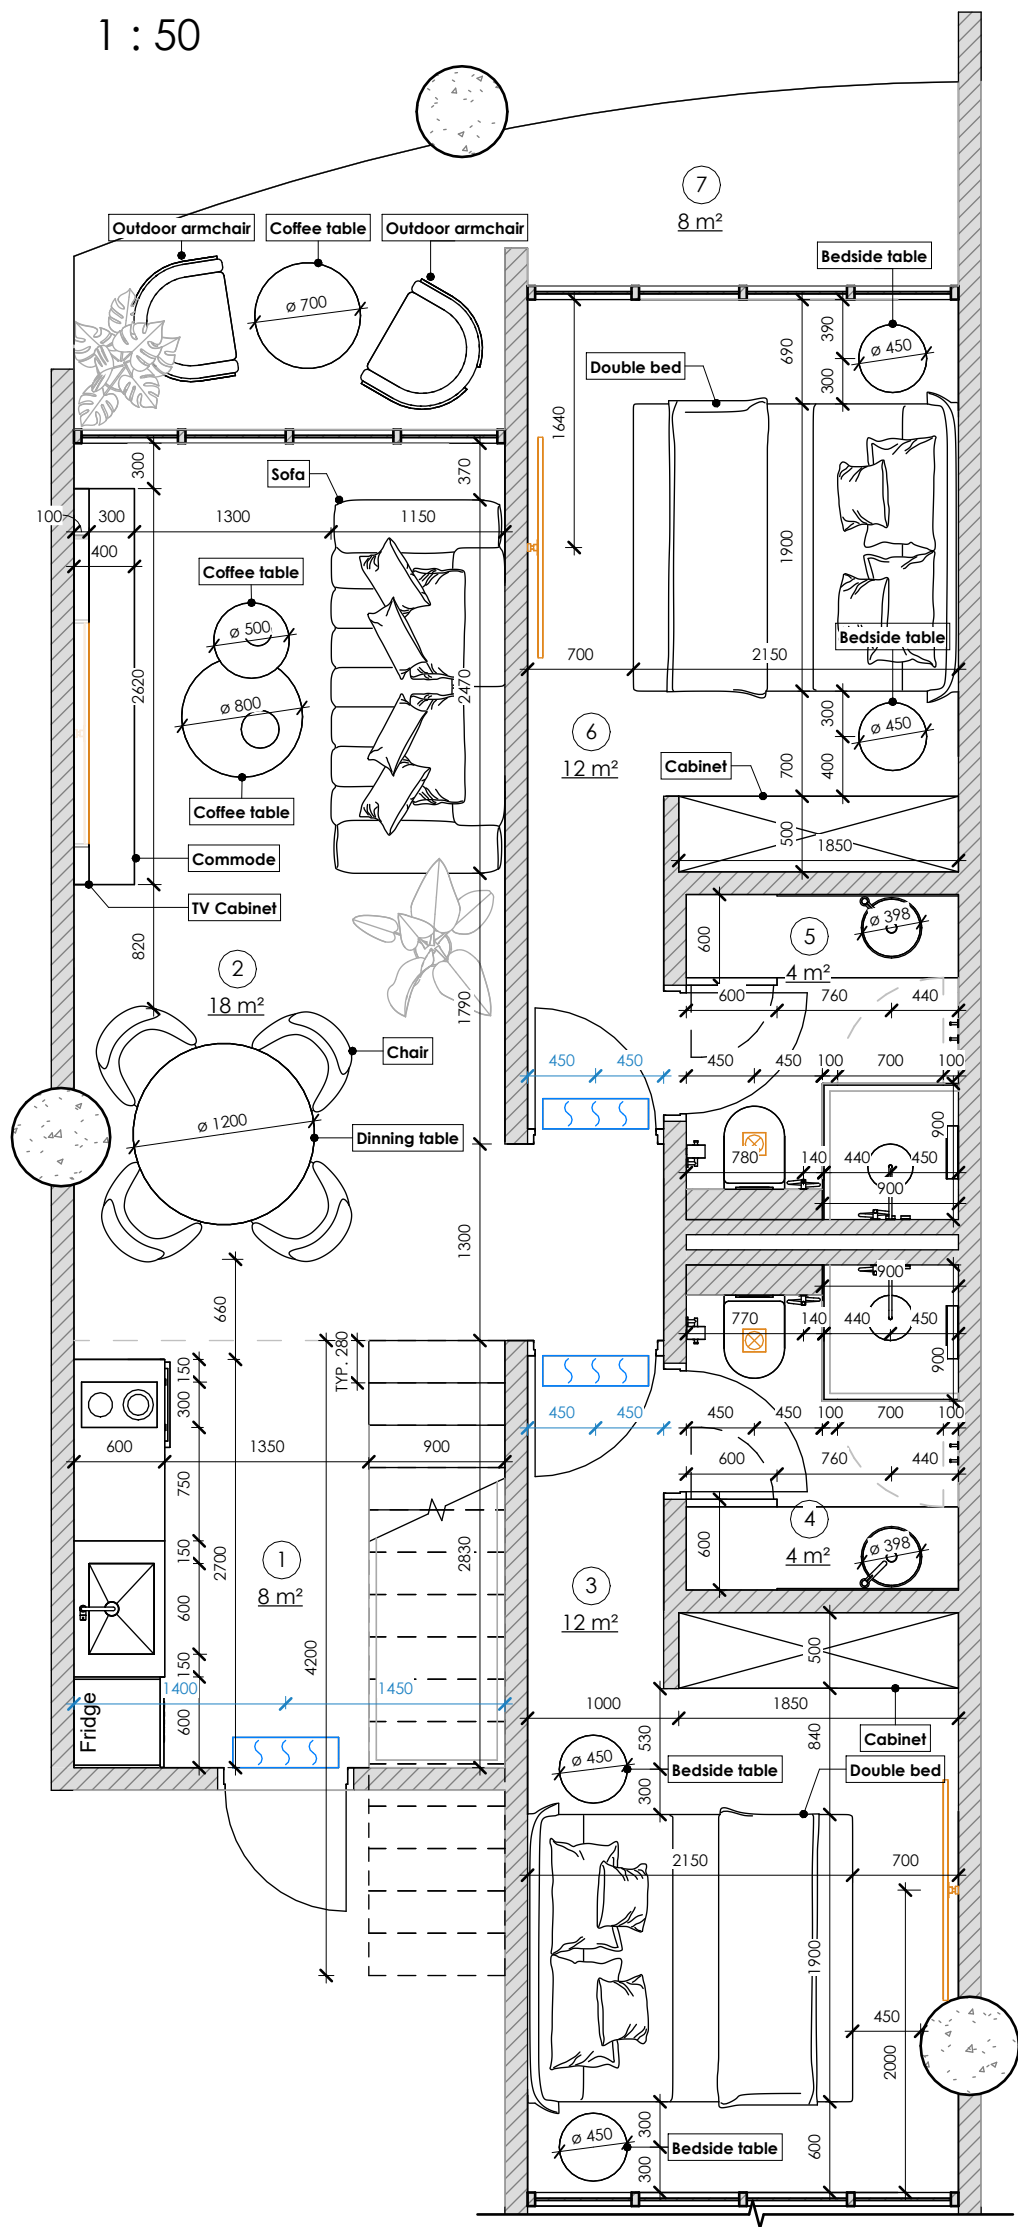

Room Schedule		
Nº	Name	Area
Level 3		
1	Kitchen	8.1 m²
2	Living room	18.1 m²
3	Bedroom	12.2 m²
4	Bathroom	3.9 m²
5	Bathroom	3.9 m²
6	Bedroom	12.2 m²
7	Terrace	8.1 m²
		66.4 m²
Roof top		
8	Roof top	78.6 m²
		78.6 m²
Total area:		144.9 m²

- Notes:
1. The contractor develops detailed drawings and coordinates the content and dimensions with the architect of the project.
 2. All dimensions are design. Before ordering, manufacturing, installation of furniture, it is imperative to perform actual measurements.
 3. The color and texture of the materials are agreed only on real samples.
 4. In case of changes in dimensions or position in space, coordinate with the project architect.
 5. Dimensions marked with "*" are approximate values. For clarification, see the "Specifications" sheet.

MELASTI ARCADE


Sheet name
Furniture layout

Scale
1 : 50



Sheet
A104

SNAAR

Bathroom

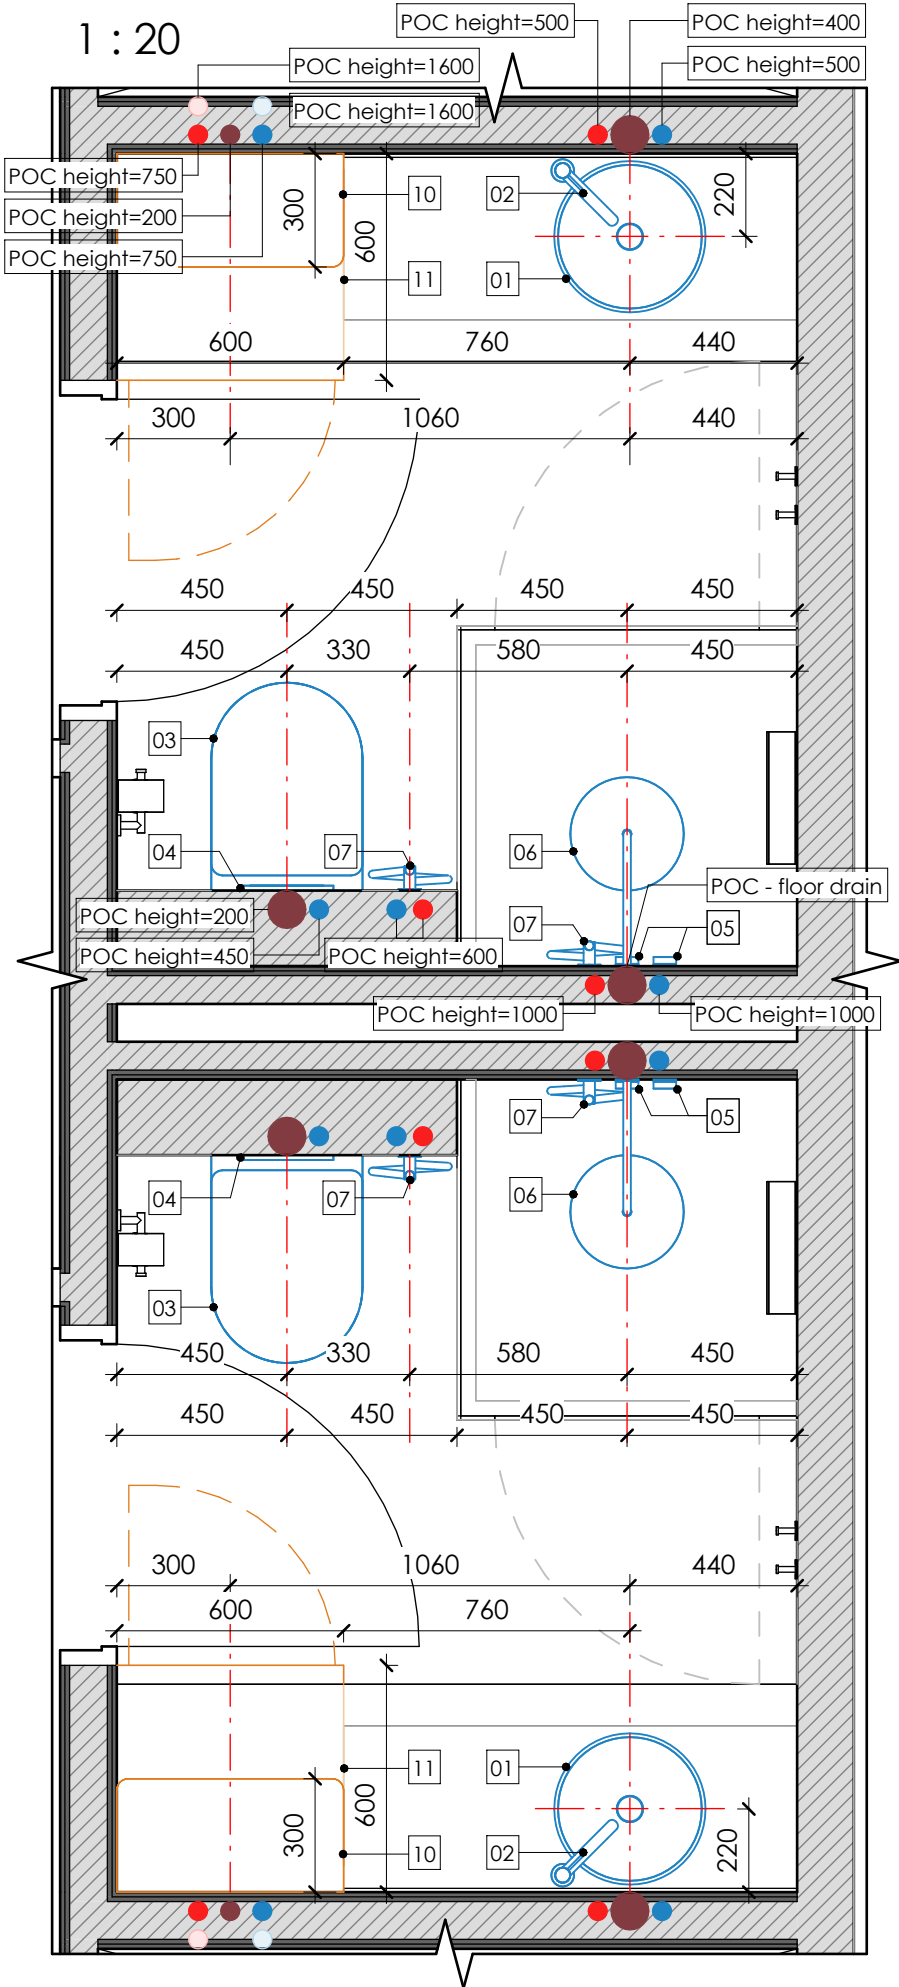

Kitchen

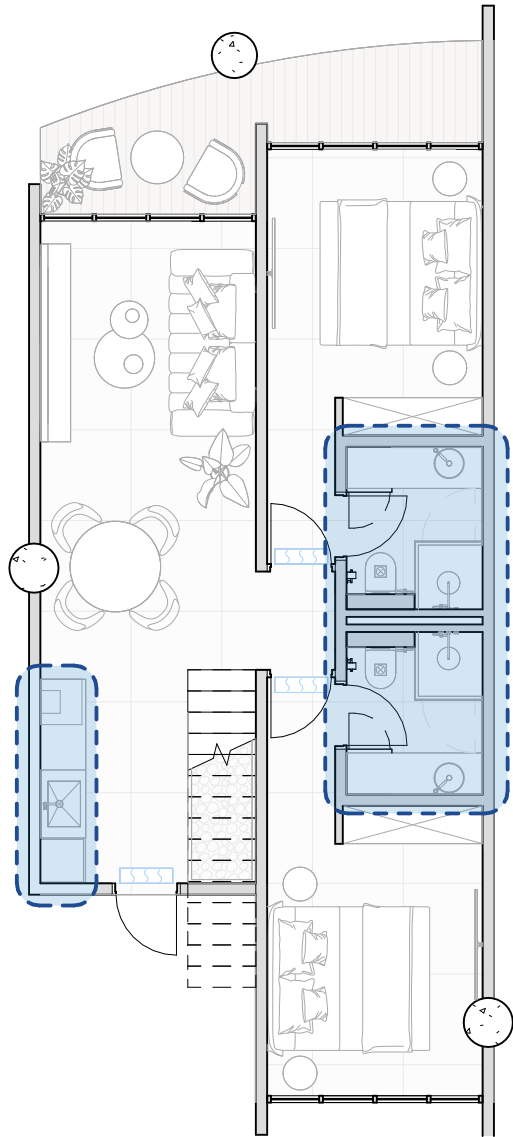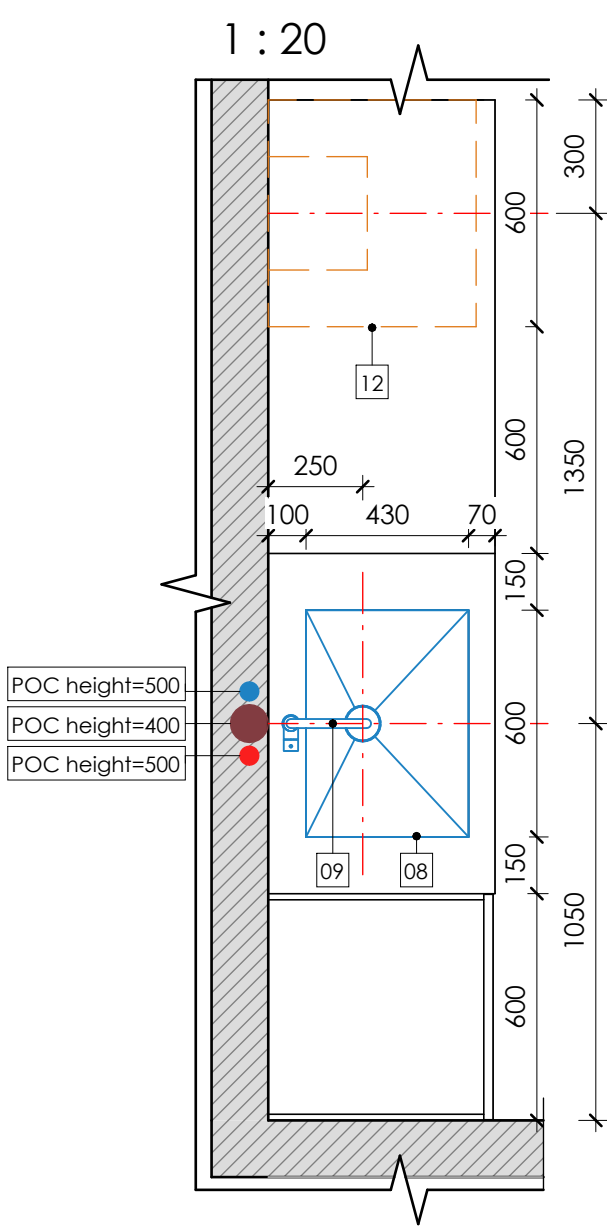

Plumbing Fixture Schedule			
Mark	Symbol	Description	Count
01		Sink	2
02		Faucet h.360	2
03		WC wall-hung	2
04		Rectangular drain button	2
05		Valve	4

Plumbing Fixture Schedule			
Mark	Symbol	Description	Count
06		Tropical showerhead	2
07		Hygienic showerhead	4
08		Kitchen undermounted sink	1
09		Kitchen faucet h.360	1

Specialty Equipment Schedule			
Mark	Symbol	Description	Count
10		Boiler	2
11		Washer Dryer Combo	2
12		Wall Hood	1

- Notes:
1. Dimensions do not include plaster and wall finishes, the dimensions must be clarified upon actual
 2. Clarify the connection according to the technical cards of the installed plumbing fixtures
 3. Models of sanitary equipment can be specified during the design process
 4. All inspection hatches of concealed installation in the finish of the wall on which they are located (specify the location)
 5. Dimensions marked with "*" are approximate values. For clarification, see the "Specifications" sheet.

Legend :

- Domestic hot water
- Domestic cold water
- Sanitary waste

MELASTI ARCADE

Sheet name

Plumbing plan


Scale
As indicated

Sheet
A105

SNAAR

Floor finish

1 : 50

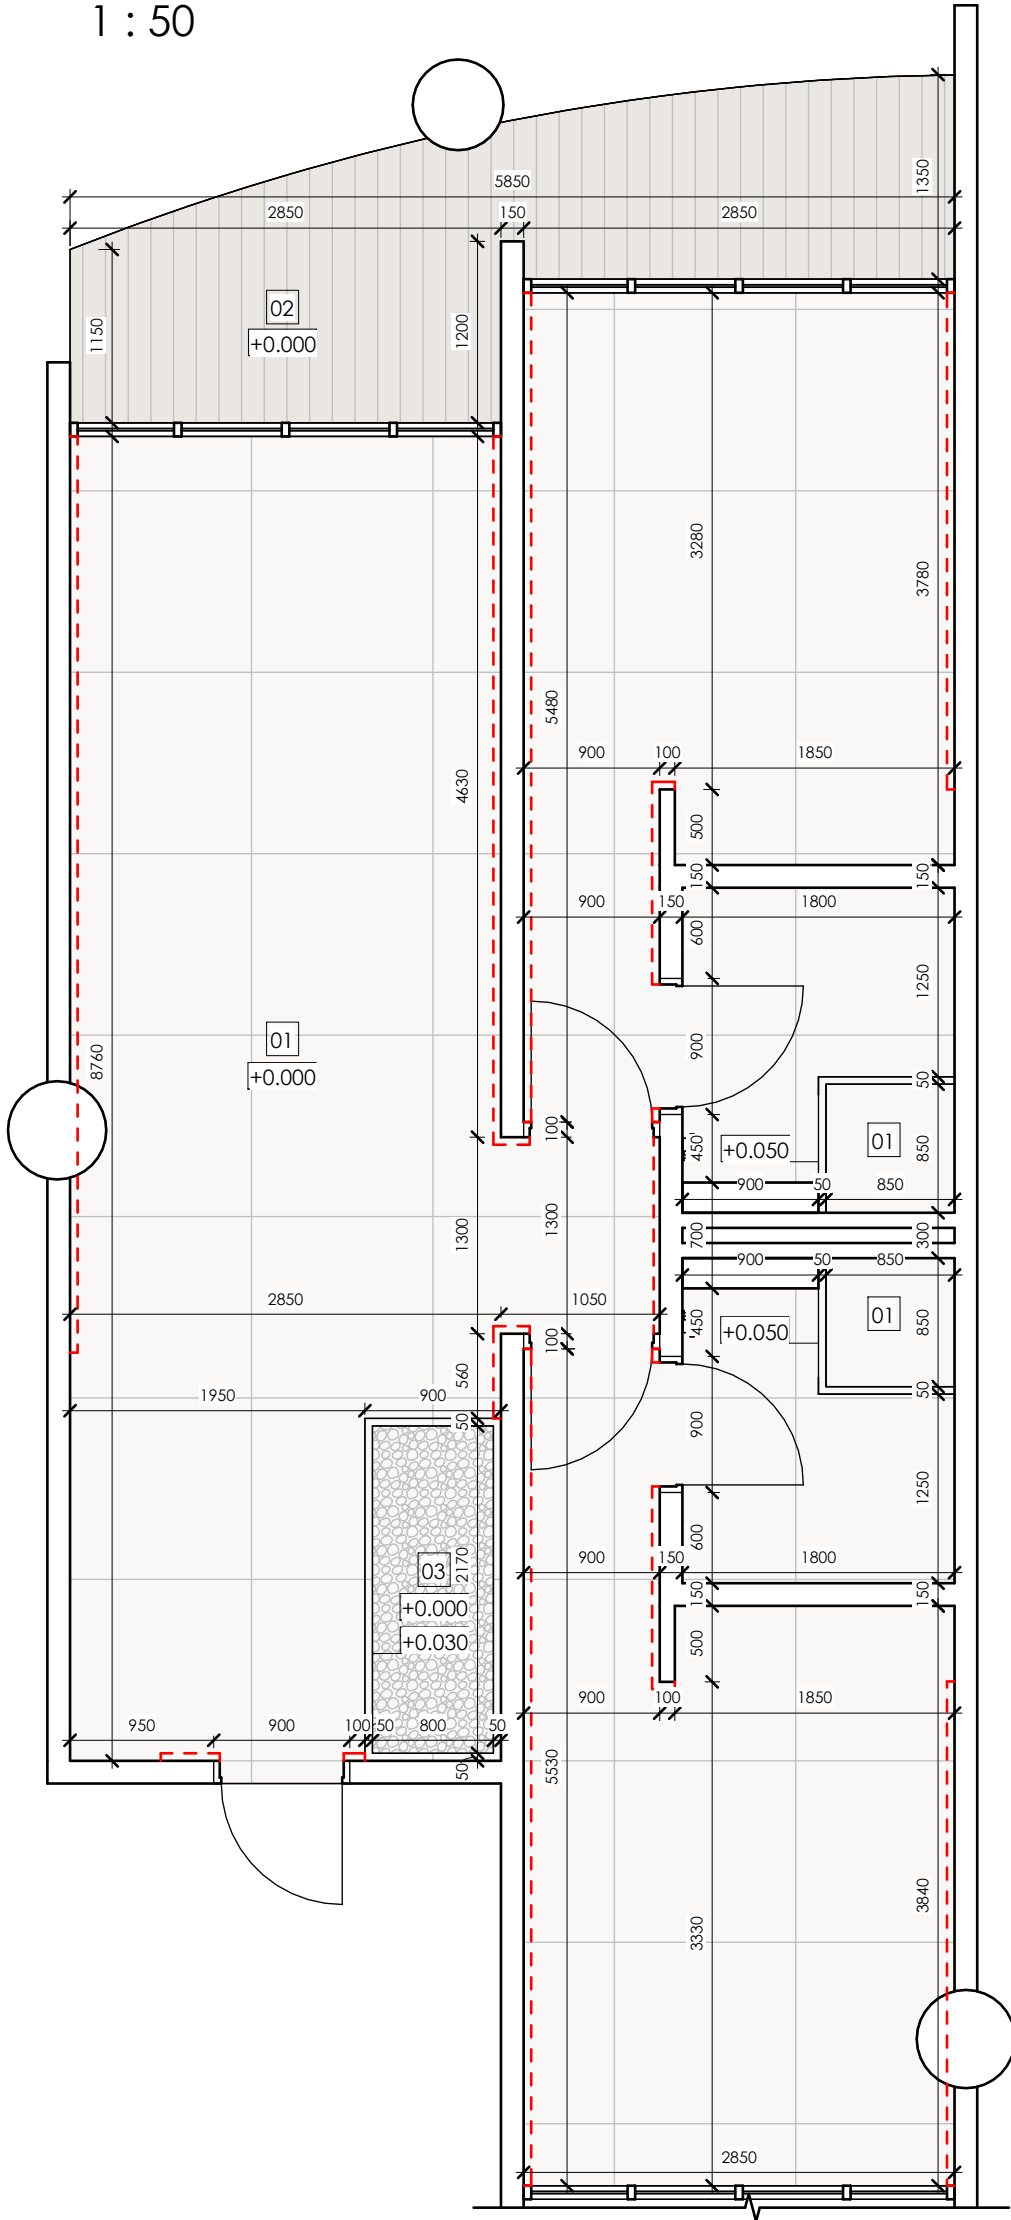

- Notes:
- 1. The area of materials is indicated without trimming and stock. Recommended stock amount - 15%
 - 2. Finishing materials are agreed separately with samples
 - 3. Floor joints should be made strictly under the bottom of the interior doors leaves
 - 4. Before laying the floor coverings, lay out dry and adjust the offset
 - 5. Dimensions are indicated without wall coverings
 - 6. Important! Dimensions are indicated for preliminary calculation, proceed with installation only after control measurements.

Floor Schedule					
Mark	Description	Material	On the plan	Appearance	Area
01	Tile type 1 (marble imitation)	Stoneware			59.1 m²
02	Patio board (light wood)	Wood			8.2 m²
03	Gravel				1.7 m²
Total area:					69.1 m²

Hidden skirting board Schedule		
Mark	Image	Length
SB-1		36 m

Legend :
- - - - - Hidden skirting board

MELASTI ARCADE

Sheet name
Floor finish plan


Scale
As indicated

Sheet
A106


SNAAR

Ceiling


1 : 50

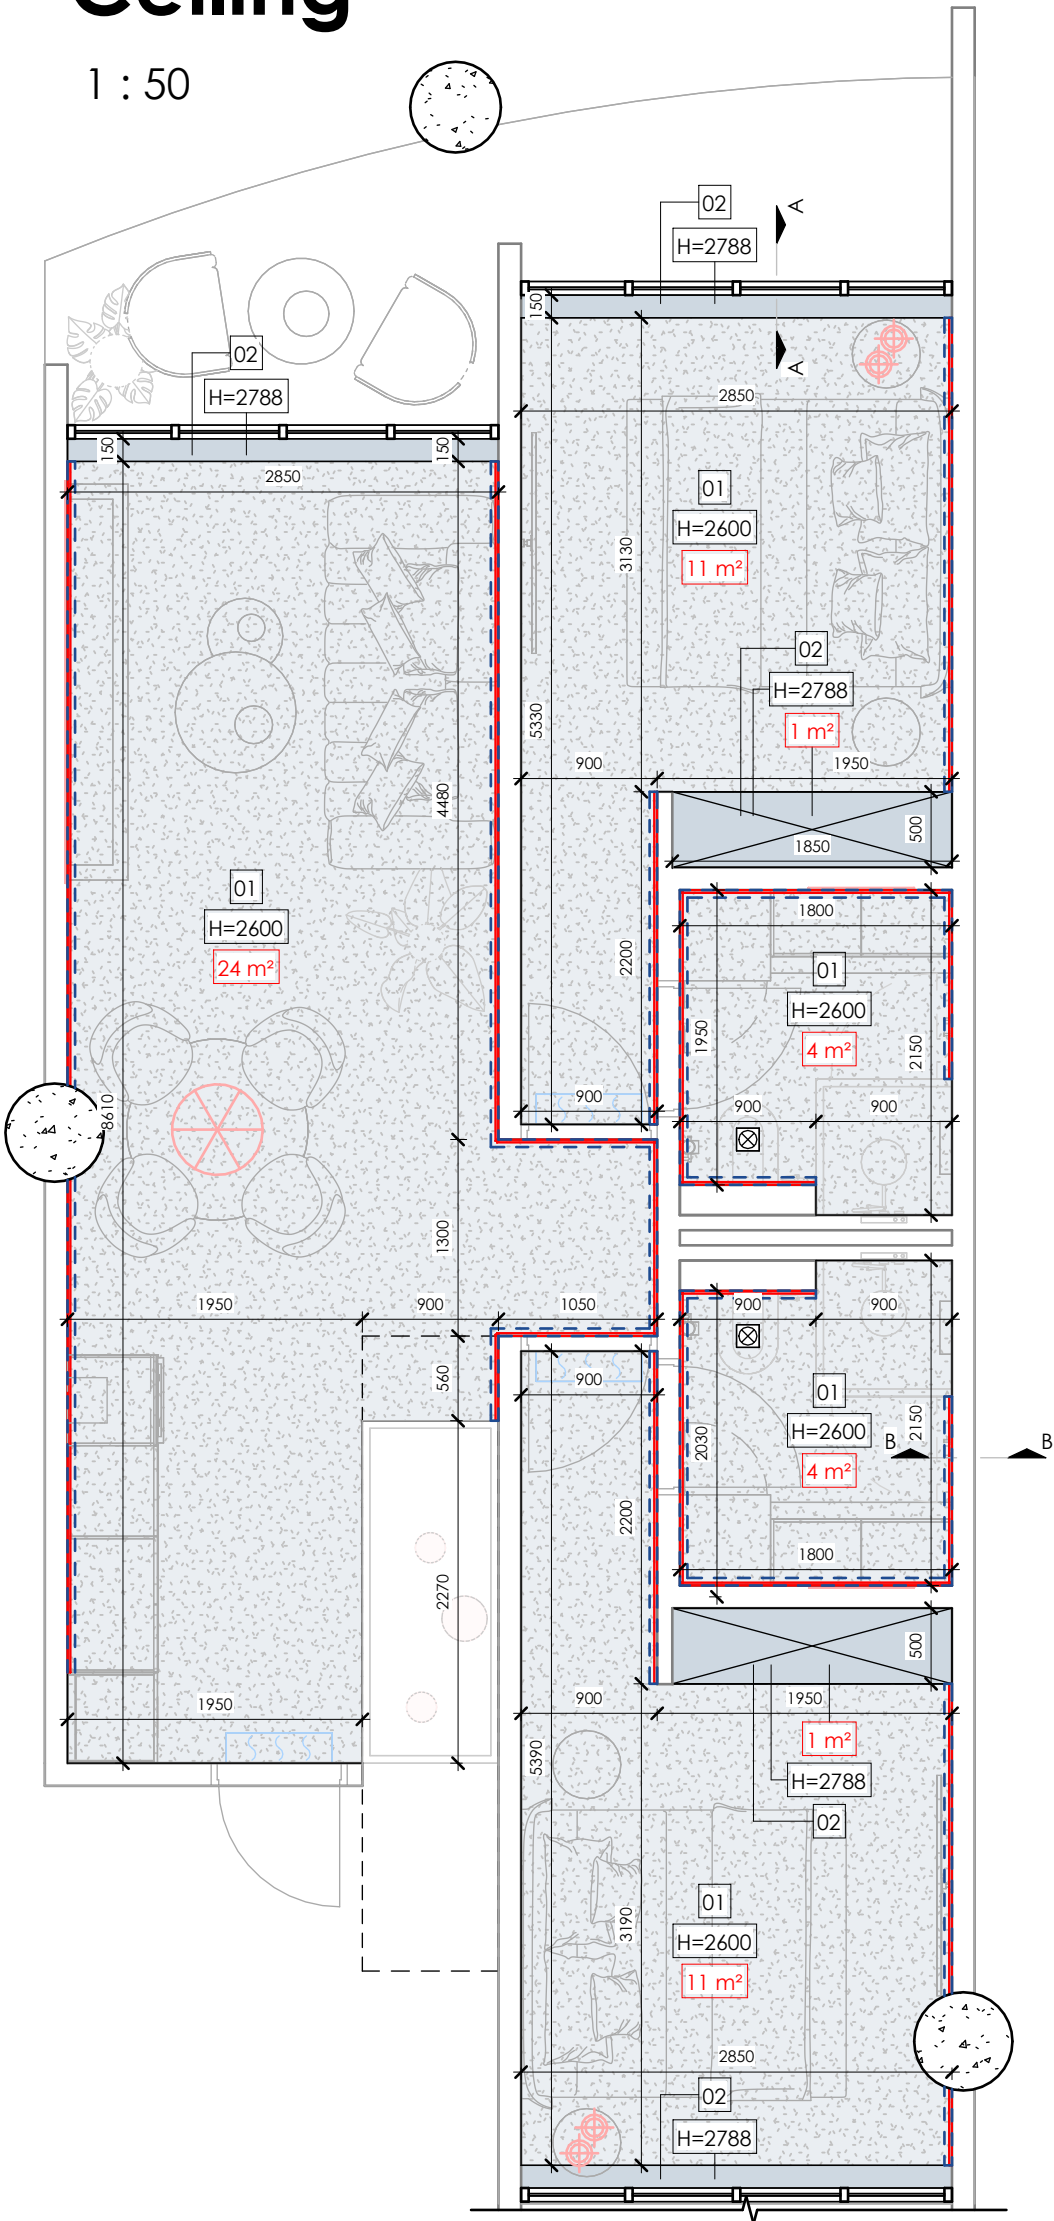

Section A-A

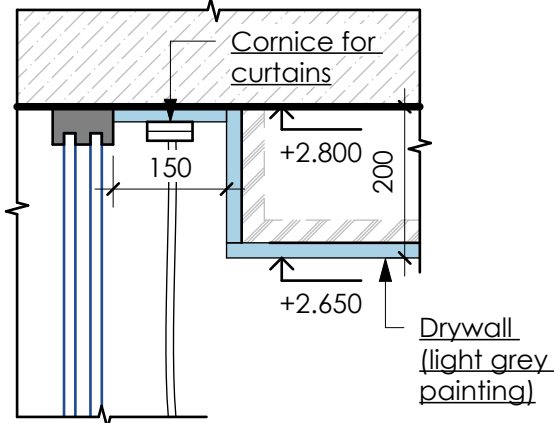

Section B-B

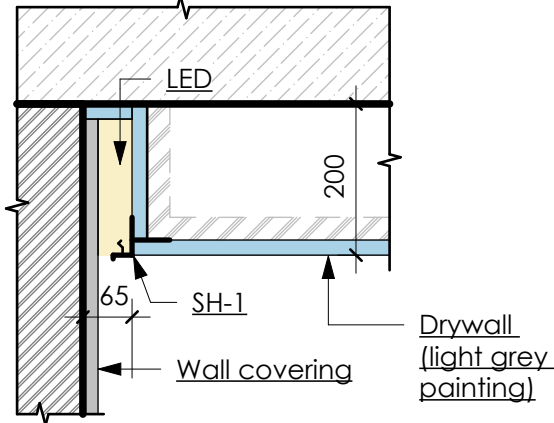

Legend :

- Ceiling LED
- Shadow seam
- H=0000 Ceiling height offset from level

Ceiling Schedule

Mark	On the plan	Description	Area	Finish
01		Suspended ceiling. 1 drywall sheet 12.5mm on metal frame	53 m²	Plaster for painting
02		1 drywall sheet 12.5mm	3 m²	Plaster for painting

Total area: 56 m²

Shadow Seam Schedule

Mark	Appearance	Description	Length
SH-1		Aluminium shadow seam profile for LED line	39,550 mm

- Notes:
- Ceiling covering - plaster, painting. Coordinate the color with samples on the object with the designer
 - Areas are indicated without calculation for pruning and stock. Recommended margin - 15%
 - Important! In the place intended for blinds, provide for a cornice, model, dimensions and bindings to agree
 - Dimensions are indicated without plaster and wall decoration

MELASTI ARCADE

Sheet name
Ceiling finish plan


Scale
As indicated

Sheet
A107

SNAAR

Lighting

1 : 50

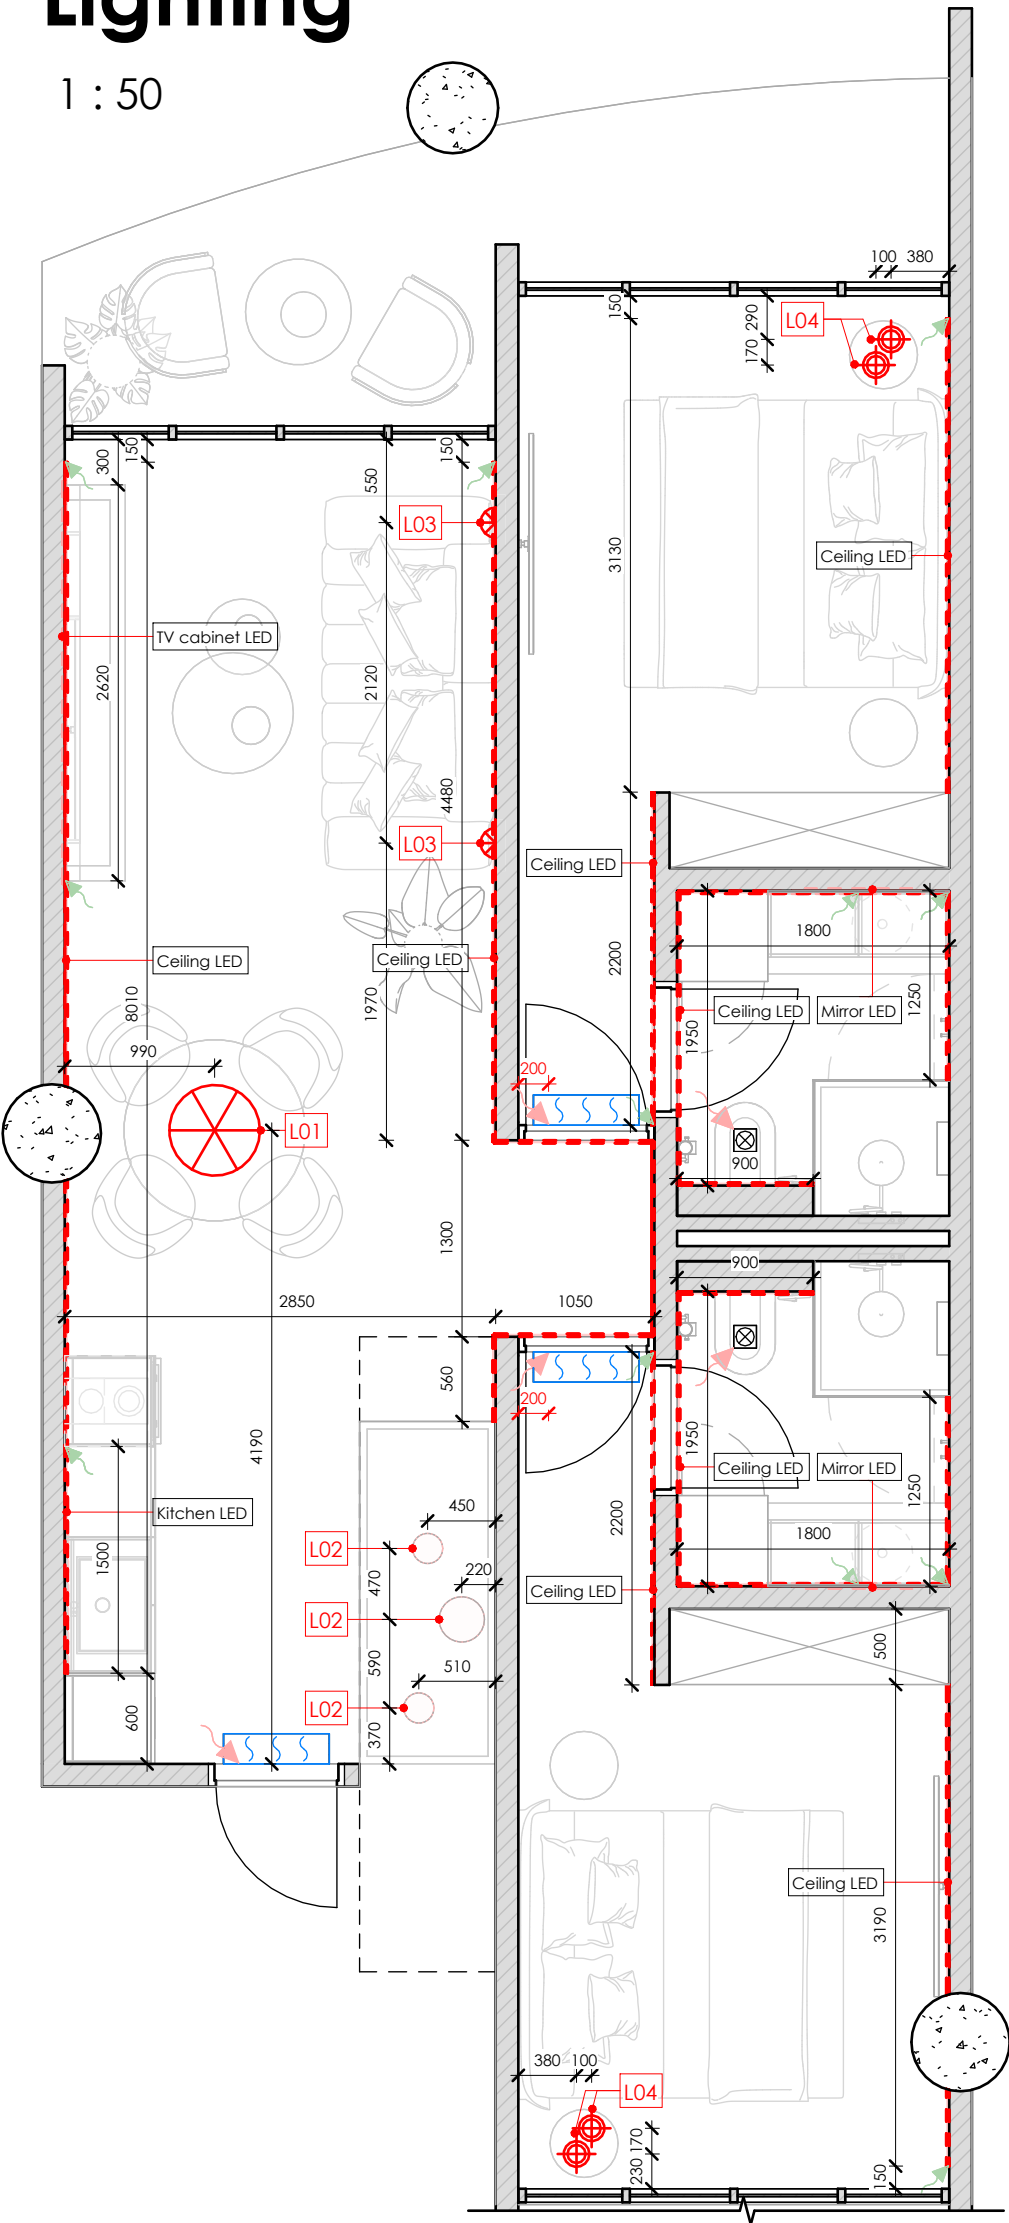

Lighting Fixture Schedule			
Description	Count	Symbol	Appearance
Chandelier, type 1	1		
Floor lamp, type 1	3		
Sconce, type 1	2		
Pendant light, type 1	4		

Grand total: 10

LED line Schedule	
Mark	Length
LED1	55,546 mm

- Notes:
1. Binding to lighting equipment is indicated in the center of the device
 2. Information about the heights of the lights and electrical outlets is on the "Wall elevations"
 3. The lengths are indicated without a margin
 4. The plan is considered together with the sheets "Ceiling finish plan", "Lighting groups plan"
 5. Dimensions marked with a "*" are for approximate placement of the floor lamp elements. See the "wall elevation" sheet for clarification

Legend :

- LED line
- 220V wire output for LED line connection
- 12V wire output for LED line connection

MELASTI ARCADE

Sheet name
Lighting plan


Scale
As indicated

Sheet
A108

SNAAR

Light groups

1 : 50

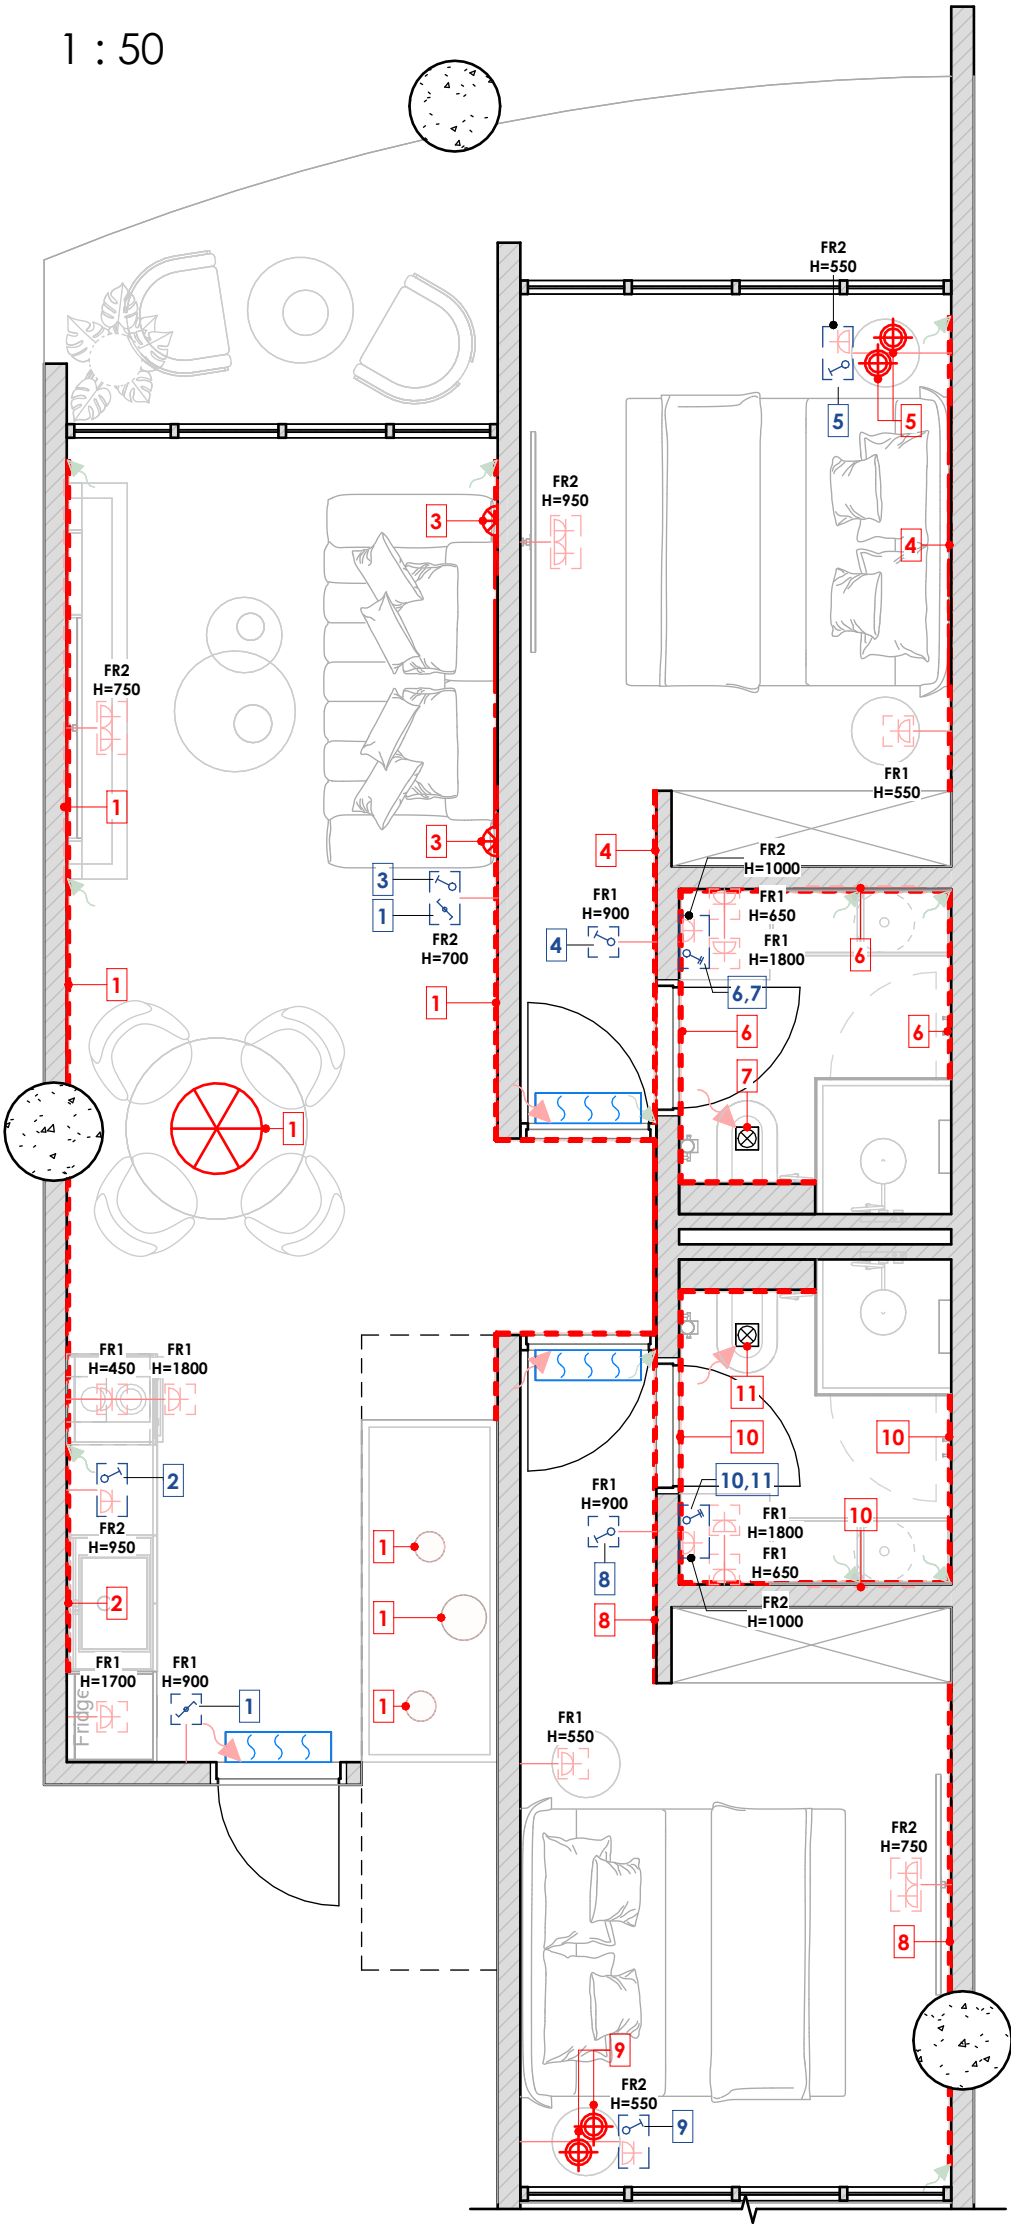

Electrical Frame Schedule			
Mark	Count	Description	Installation type
FR1	12	Frame 1-post	Wall mounted
FR2	9	Frame 2-post	Wall mounted
Total:	21		

Legend :

- LED line
- 220V wire output for LED line connection
- 12V wire output for LED line connection

- Notes:
- The size is specified to the center of the element (both in height and in width)
 - Read the diagram along with 'Lighting groups plan', and "Electrical specification"

MELASTI ARCADE

Sheet name
Lighting groups plan


Scale
As indicated

Sheet
A109

SNAAR

Sockets & electrical output

1 : 50

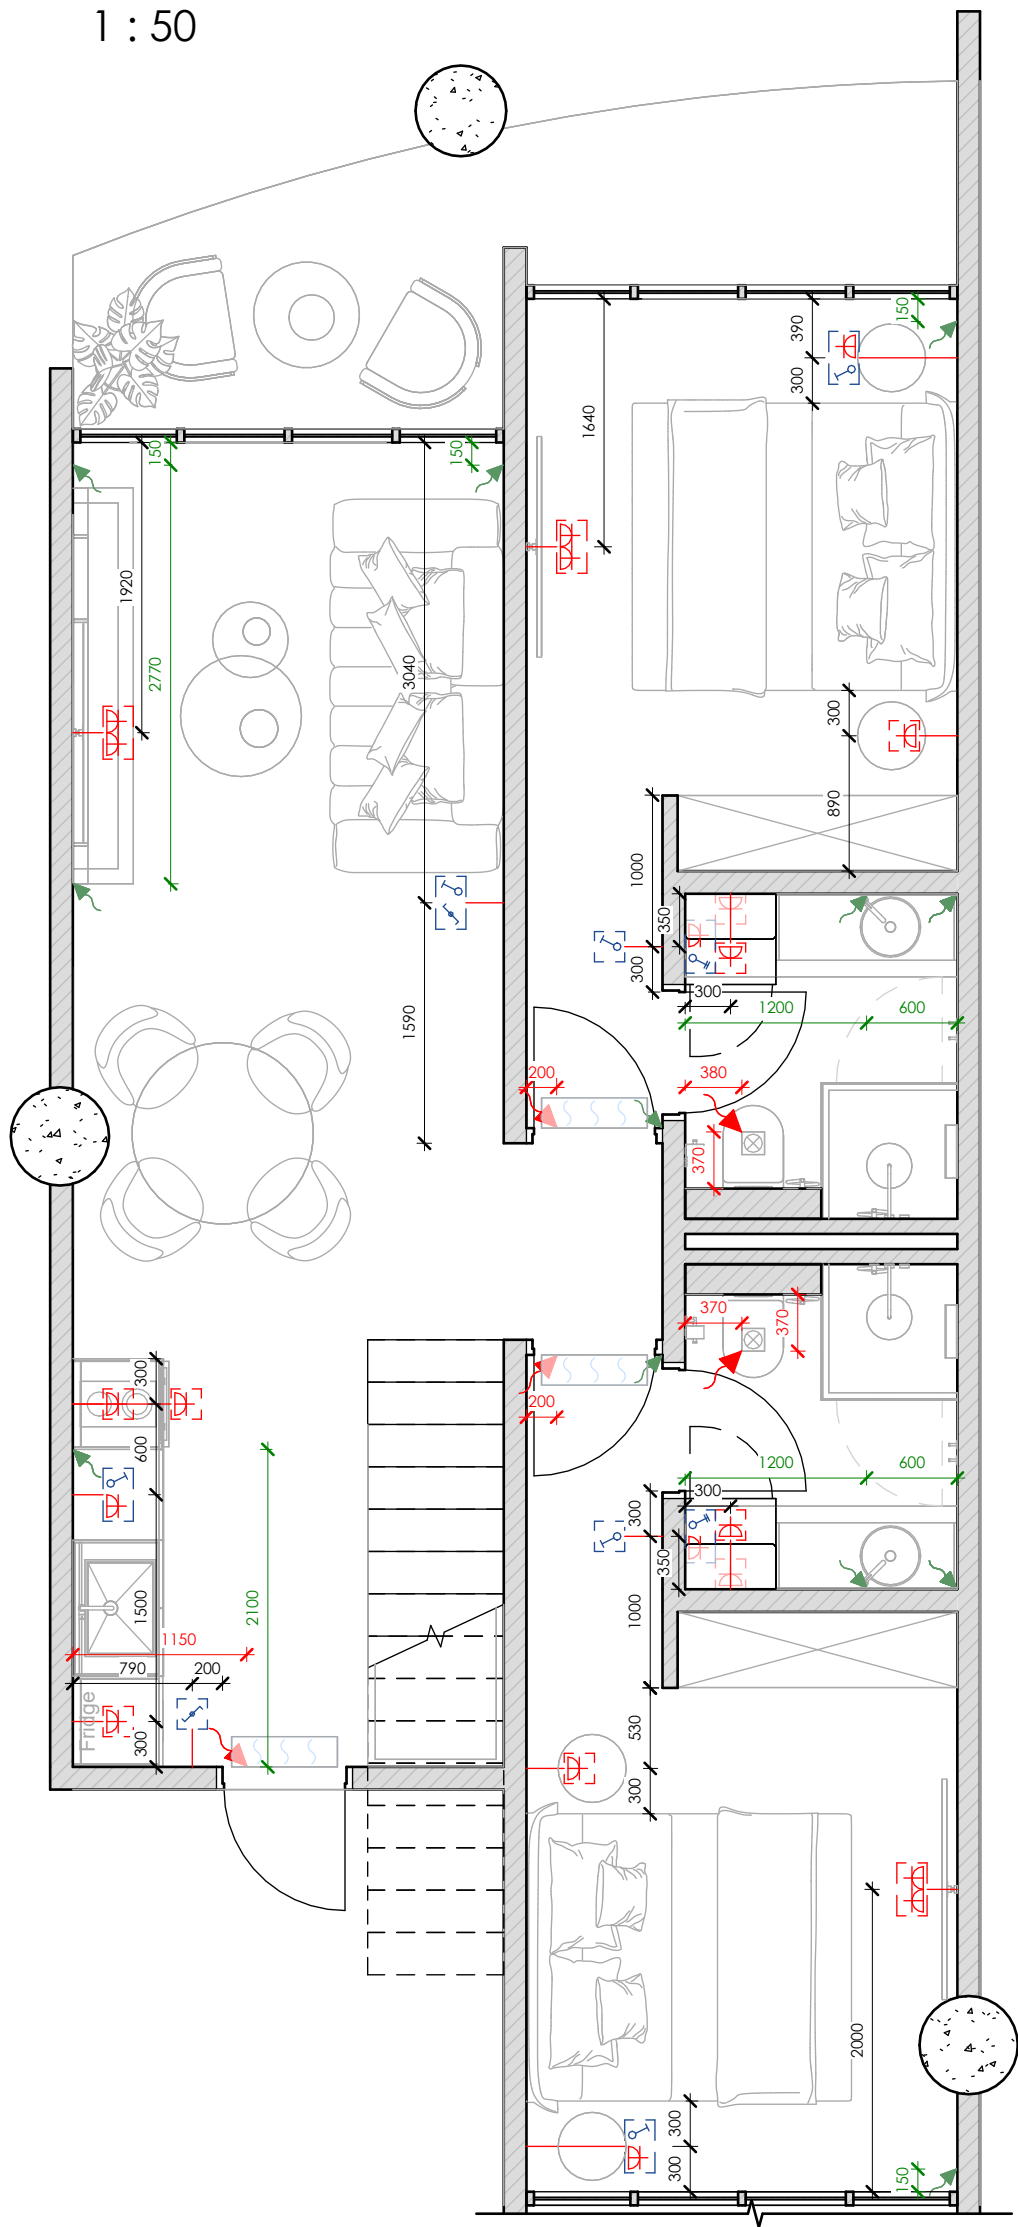

Socket/ Switch/ Output Schedule		
Symbol	Count	Description
	6	One-key switch
	2	One-key through switch
	2	Two-key switch
	17	12V Output
	19	220V Socket
	5	220V Output

Total: 51

Notes:
1. The size is specified to the center of the element (both in height and in width)
2. Read the diagram along with 'Lighting groups plan', and 'Electrical specification'

MELASTI ARCADE

Sheet name
Sockets & electrical
output layout


Scale
1 : 50

Sheet
A110

SNAAR

Wall finish

1 : 50

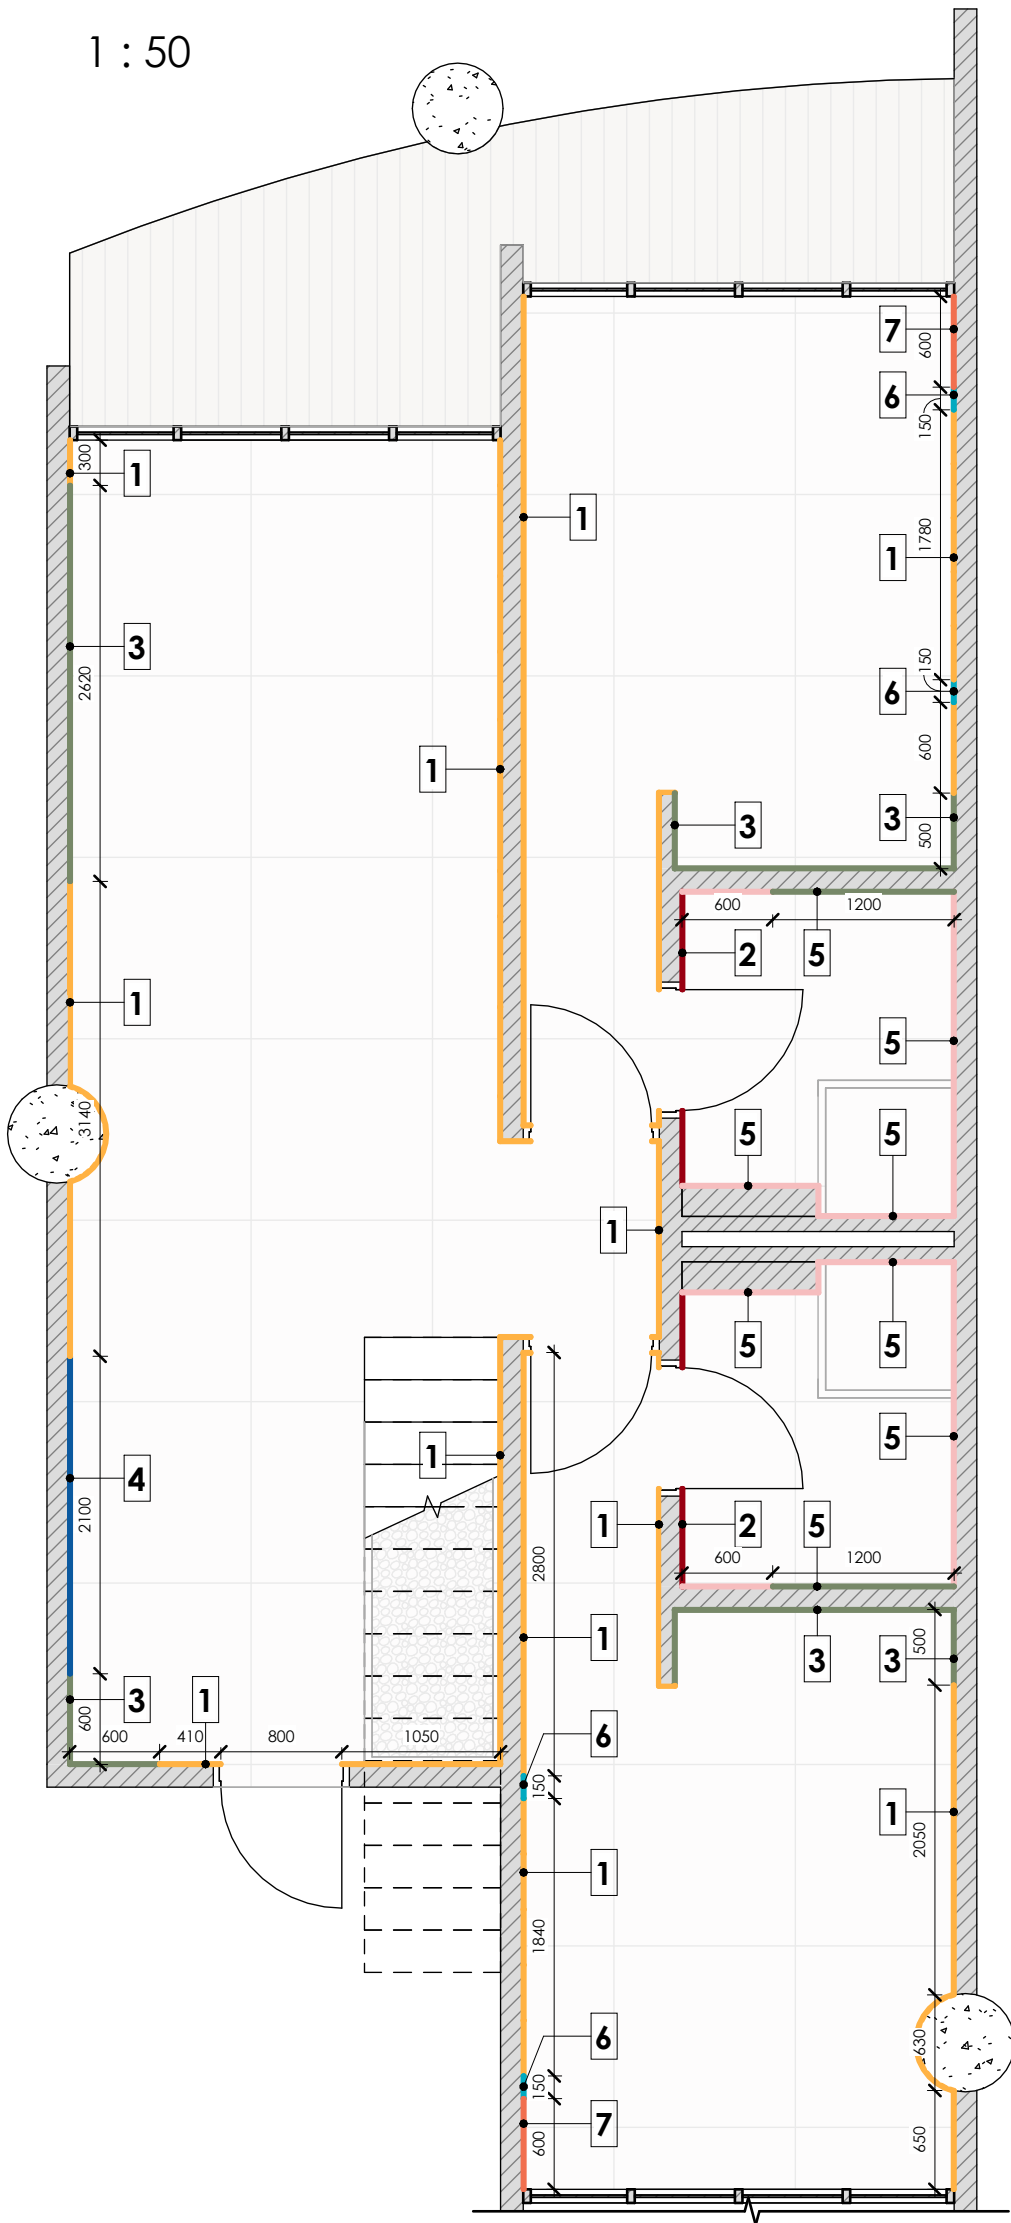

- Notes:
- 1. All sizes are specified on site
 - 2. Inform the architect about all discrepancies
 - 3. Check the sheet with the wall markings

Wall Finish Schedule					
Mark	Description	On the plan	Pattern	Visualiza tion	Area
1	Decorative plaster (grey)				95 m²
2	MDF panel (dark wood)				7 m²
3	Plaster without finishing (behind furniture)				28 m²
4	Tile, type 1 (marble imitation)				4 m²

Wall Finish Schedule					
Mark	Description	On the plan	Pattern	Visualiza tion	Area
5	Tile, type 2 (wood imitation)				27 m²
6	MDF panel (bronze)				2 m²
7	MDF panel (silver)				3 m²

MELASTI ARCADE

Sheet name
Wall finish plan


Scale
1 : 50

Sheet
A112

SNAAR

Marking

1 : 50

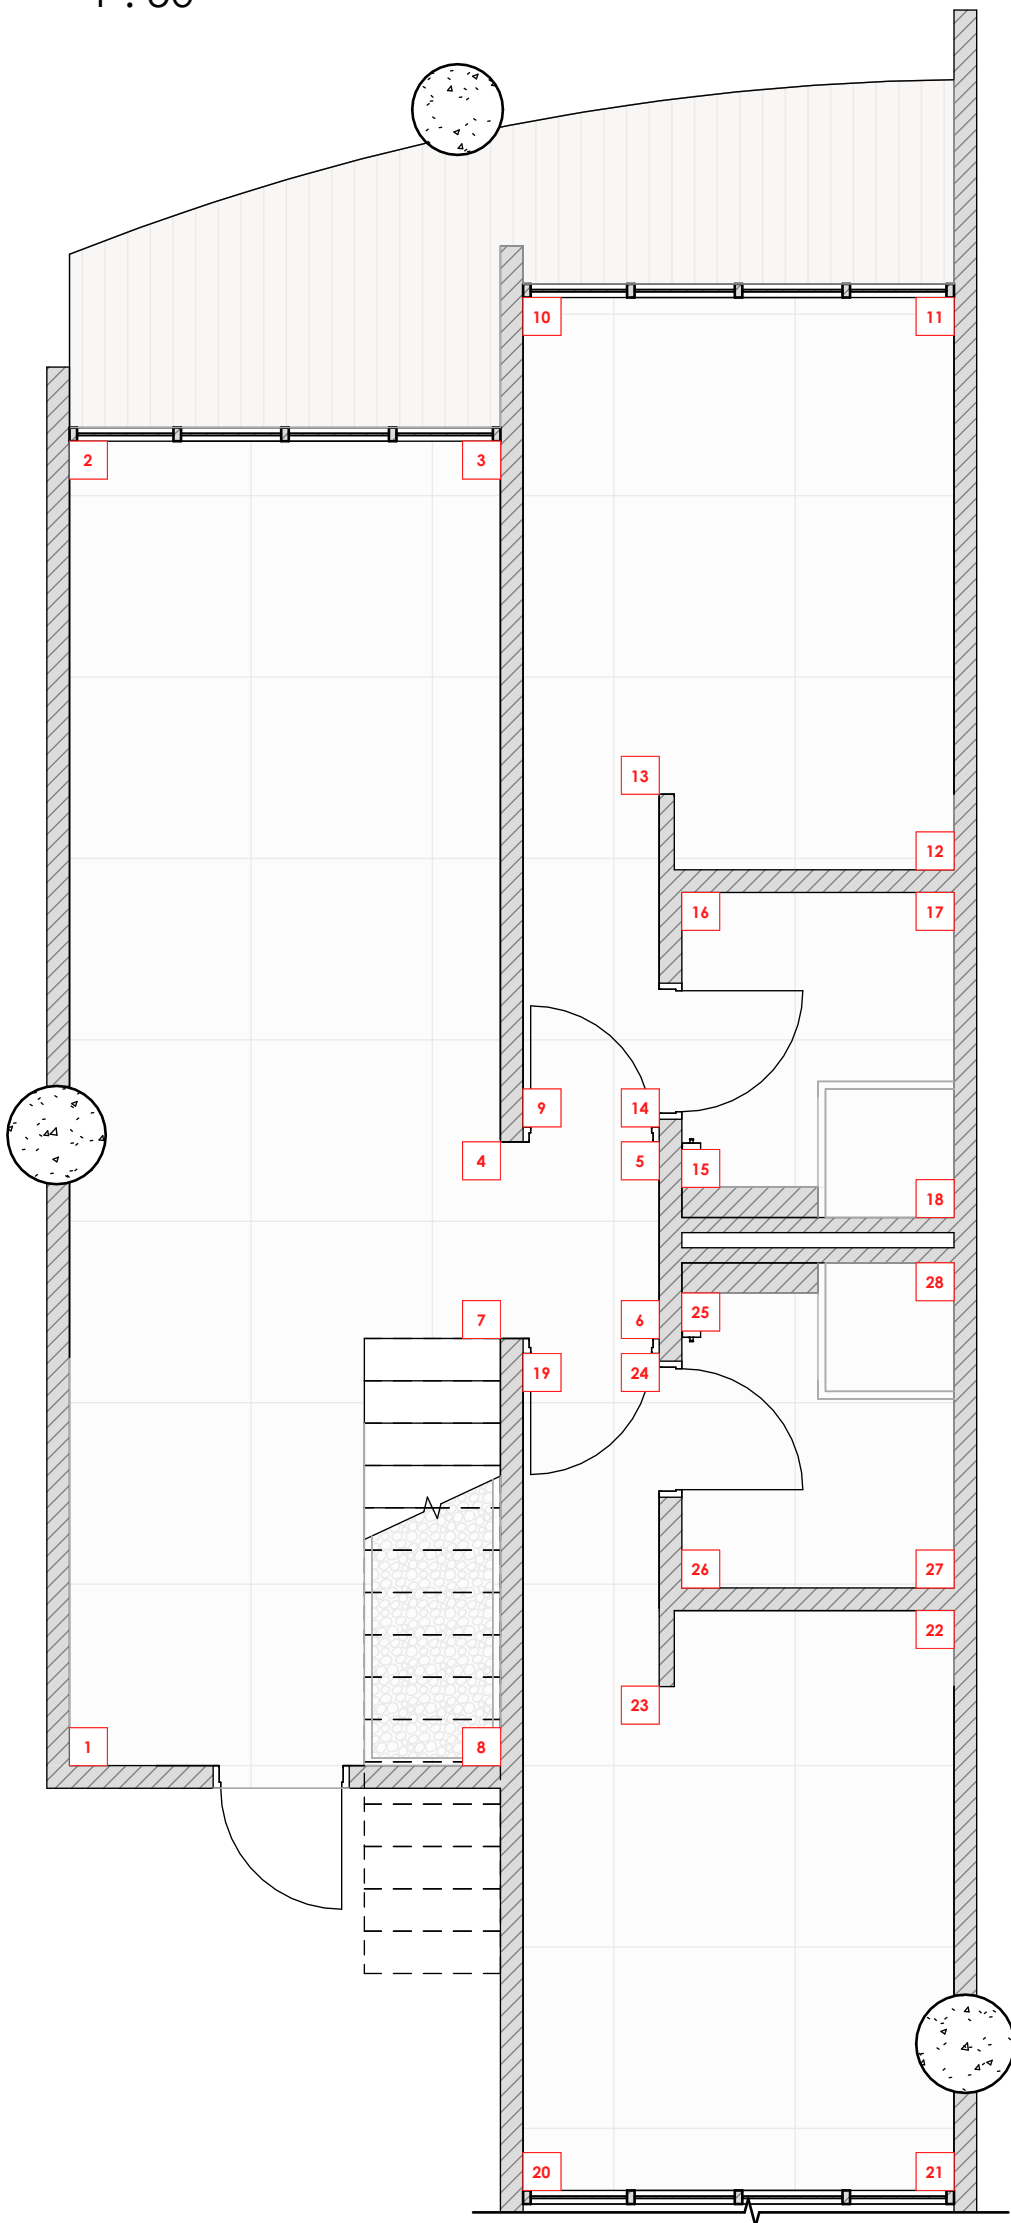

Notes:
1. Check the sheet
with the wall
markings

MELASTI ARCADE

Sheet name

Marking plan


Scale

1 : 50


Sheet

A113

SNAAR

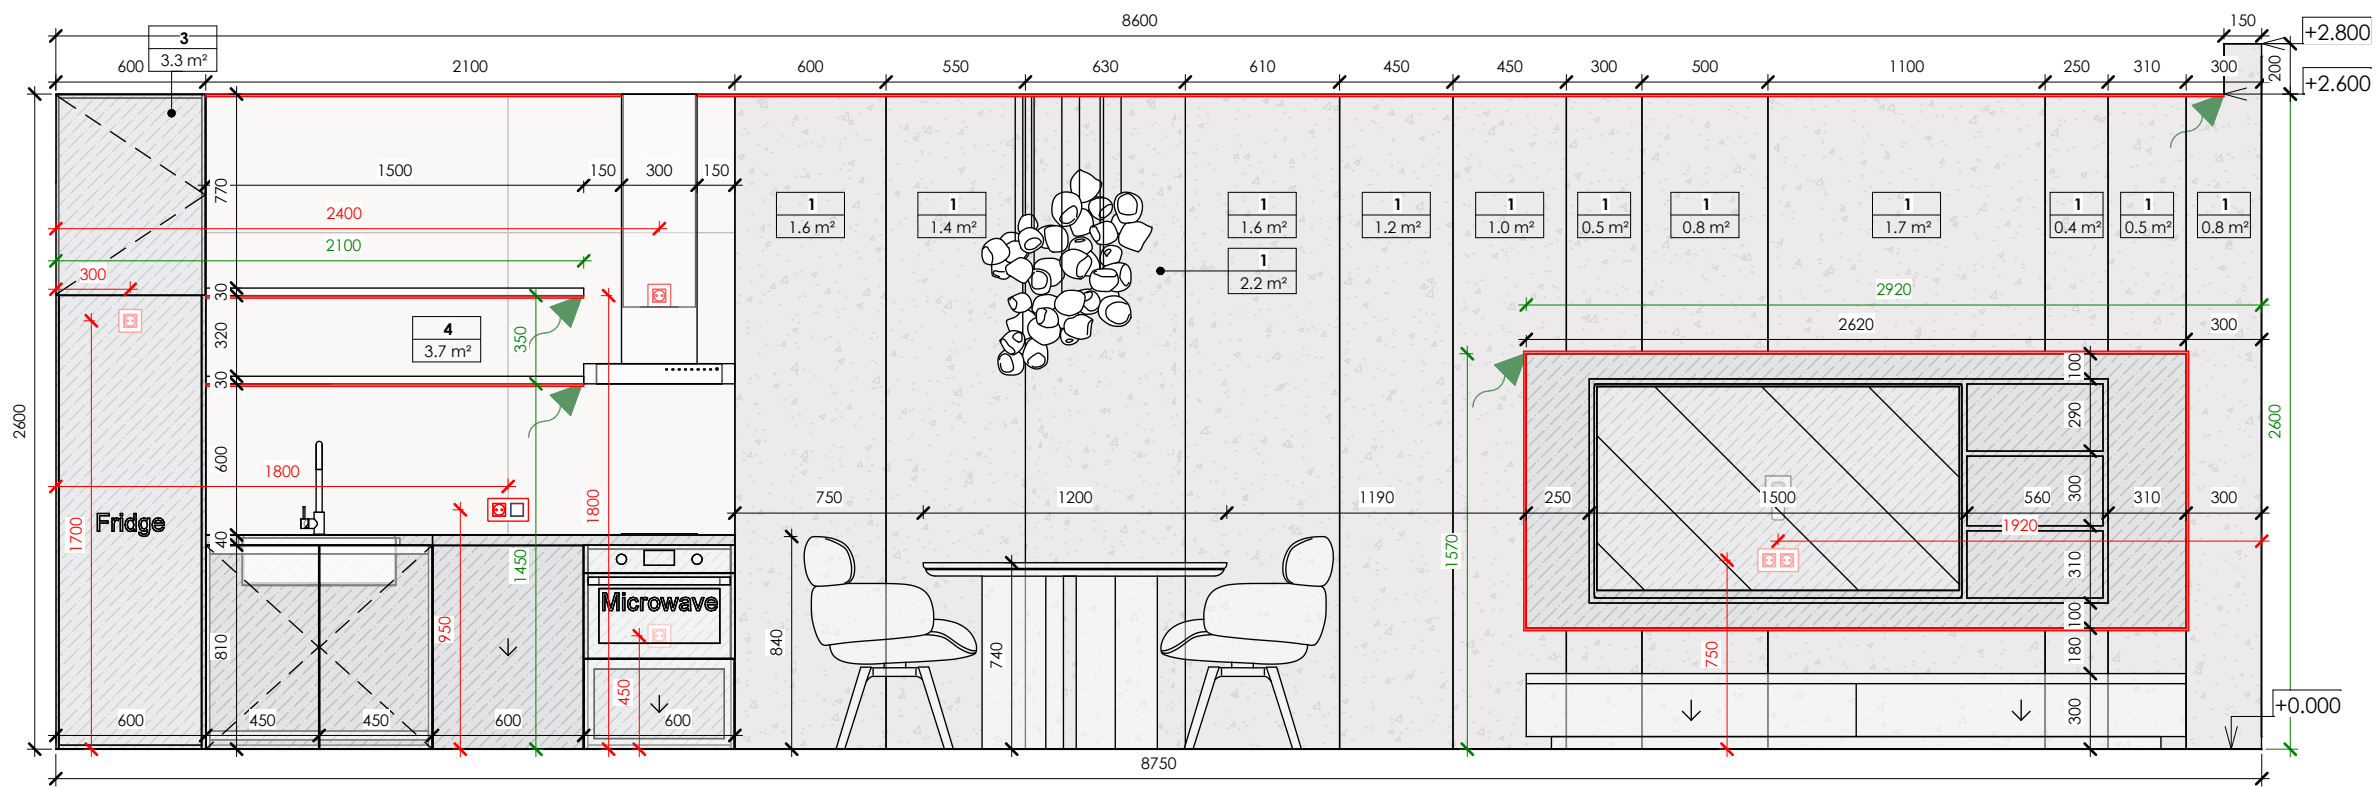


1-2

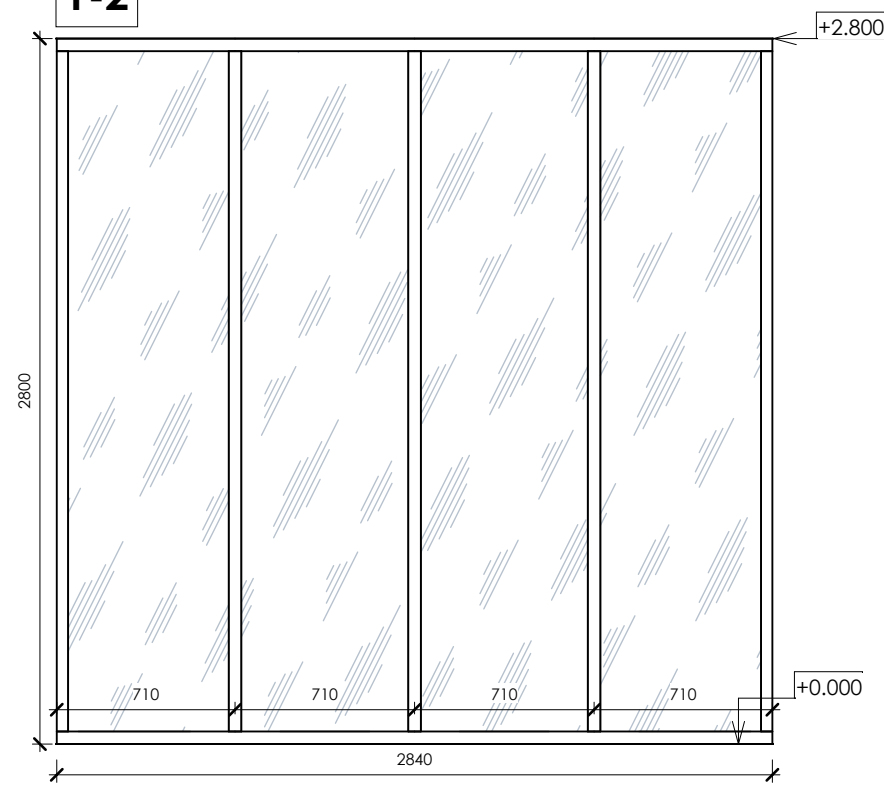

2-3

General Wall Finish Schedule			
Mark	Finish	Pattern	Total area
1	Decorative plaster (grey)		95 m²
2	MDF panel (dark wood)		7 m²
3	Plaster without finishing (behind furniture)		28 m²

3-4

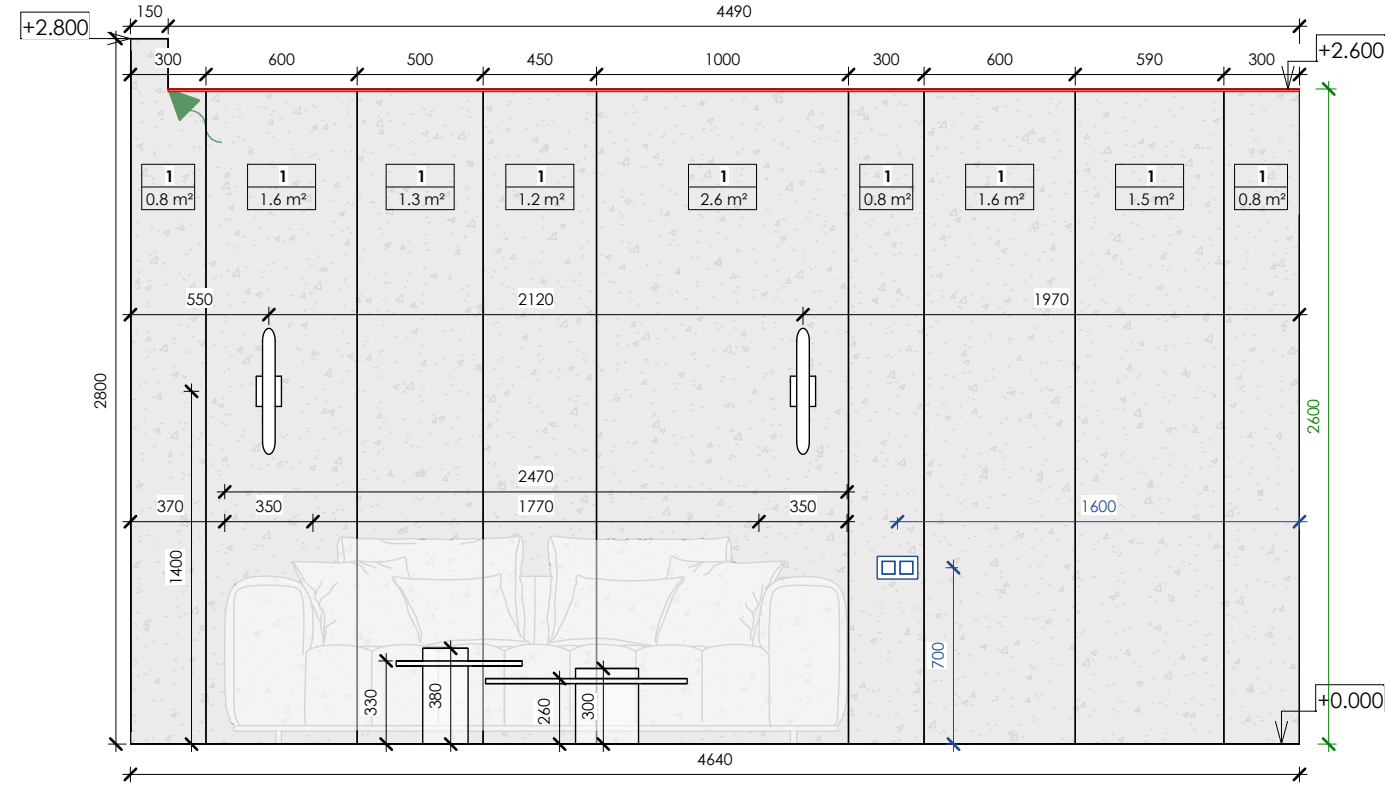

General Wall Finish Schedule			
Mark	Finish	Pattern	Total area
4	Tile, type 1 (marble imitation)		4 m²
5	Tile, type 2 (wood imitation)		27 m²

General Wall Finish Schedule			
Mark	Finish	Pattern	Total area
6	MDF panel (bronze)		2 m²
7	MDF panel (silver)		3 m²

Notes:
1. All dimensions are to be specified on the spot
2. Notify the architect of all discrepancies

Legend :

- LED line
- 220V wire output for LED
- 12V wire output for LED
- One-key switch
- One-key through switch
- Two-key switch
- 220V socket


MELASTI ARCADE

Sheet name
Wall elevations

Scale
As indicated


Sheet
A114

SNAAR

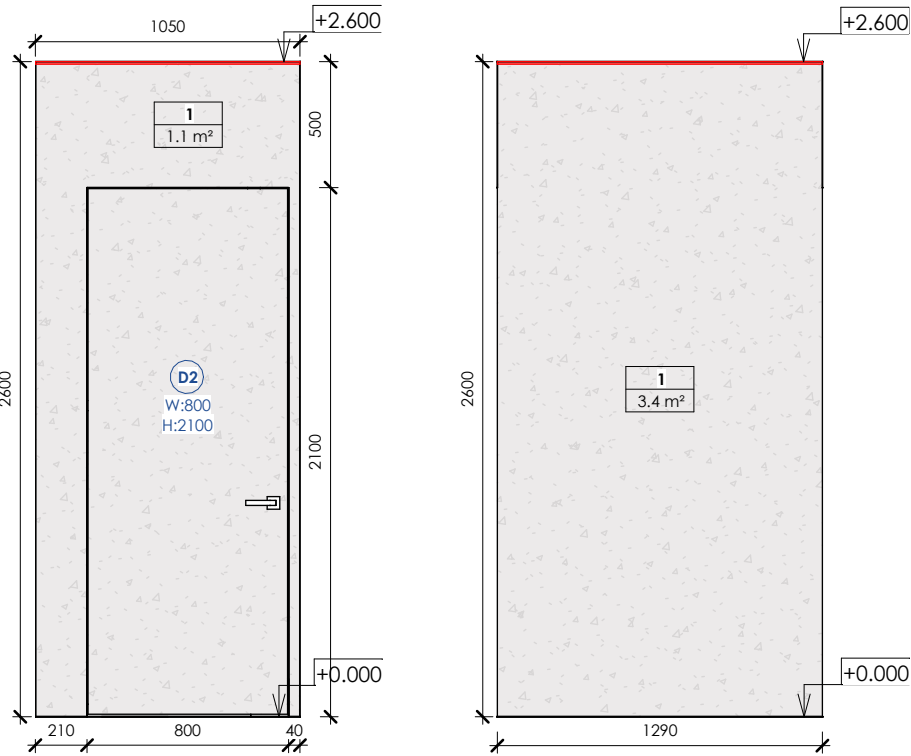


4-5


5-6

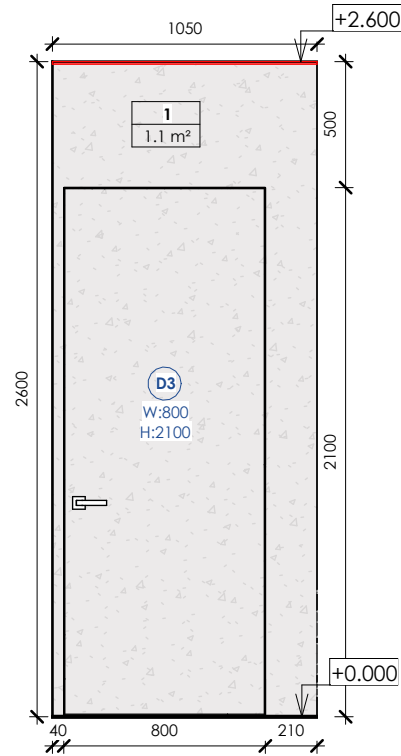

6-7

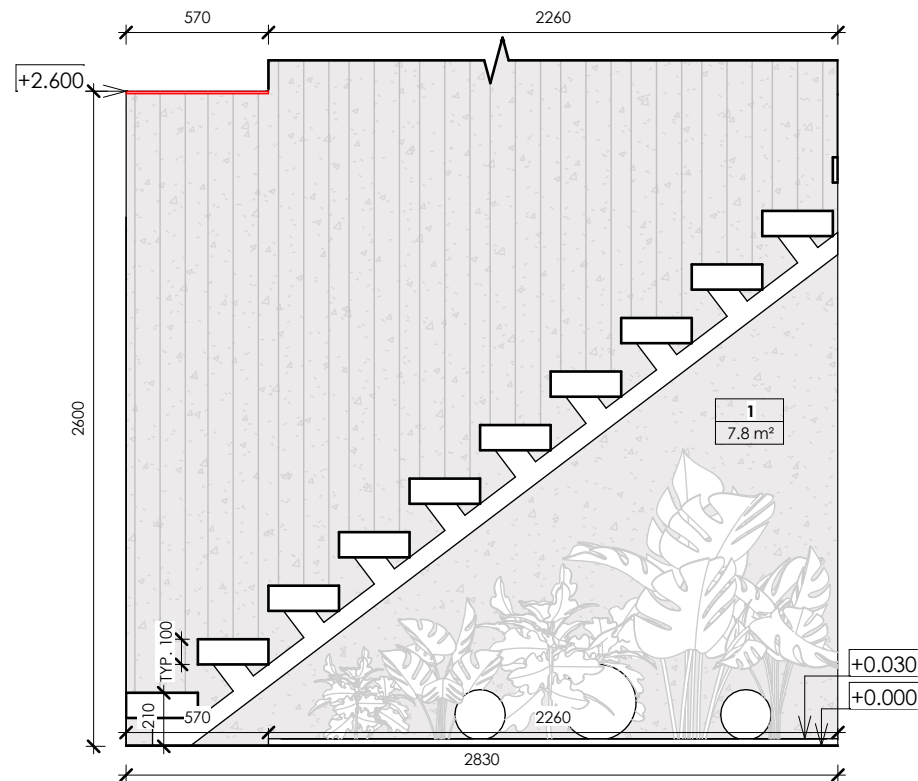

7-8

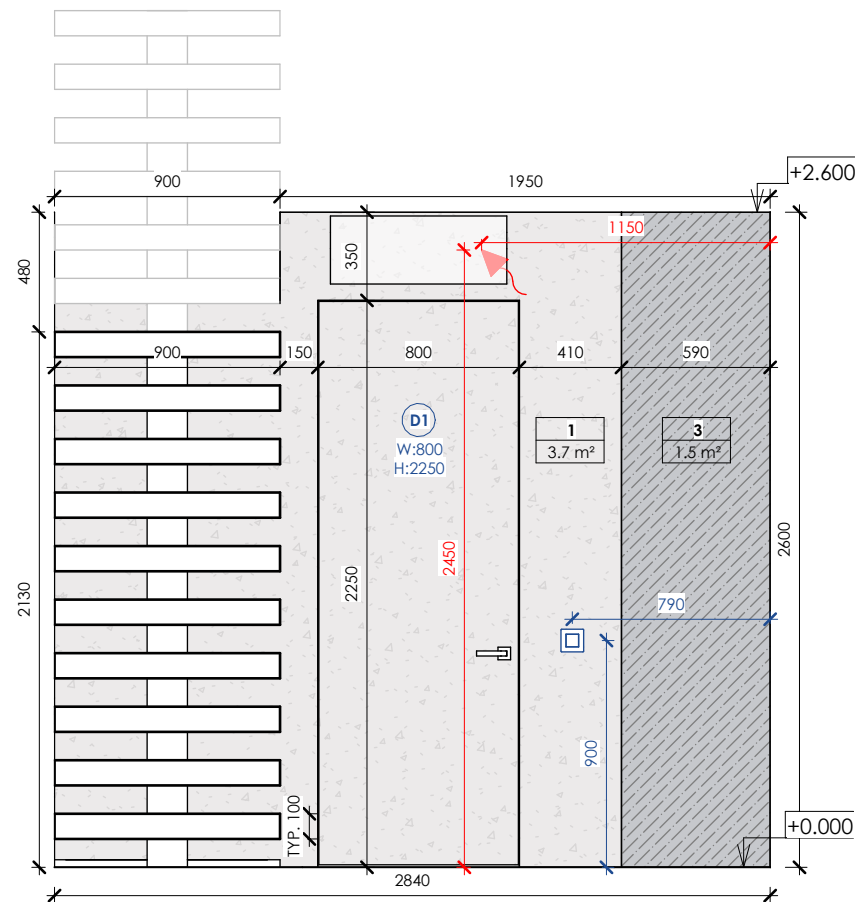

8-1

General Wall Finish Schedule			
Mark	Finish	Pattern	Total area
1	Decorative plaster (grey)		95 m²
2	MDF panel (dark wood)		7 m²
3	Plaster without finishing (behind furniture)		28 m²
4	Tile, type 1 (marble imitation)		4 m²
5	Tile, type 2 (wood imitation)		27 m²
6	MDF panel (bronze)		2 m²
7	MDF panel (silver)		3 m²

Notes:
1. All dimensions are to be specified on the spot
2. Notify the architect of all discrepancies

Legend :

- LED line
- 220V wire output for LED
- 12V wire output for LED
- One-key switch
- One-key through switch
- Two-key switch
- 220V socket

MELASTI ARCADE

Sheet name

Wall elevations







Scale

As indicated

Sheet

A115

SNAAR

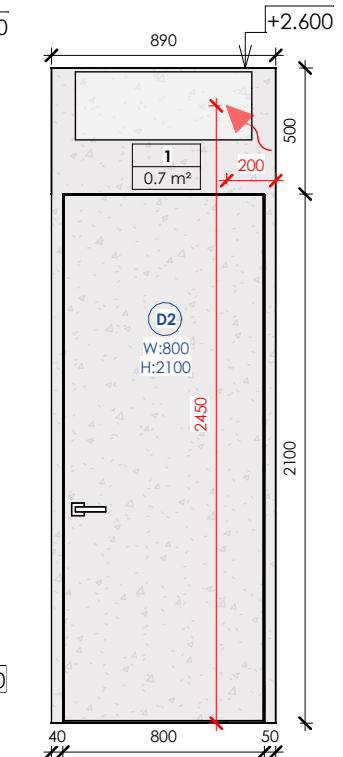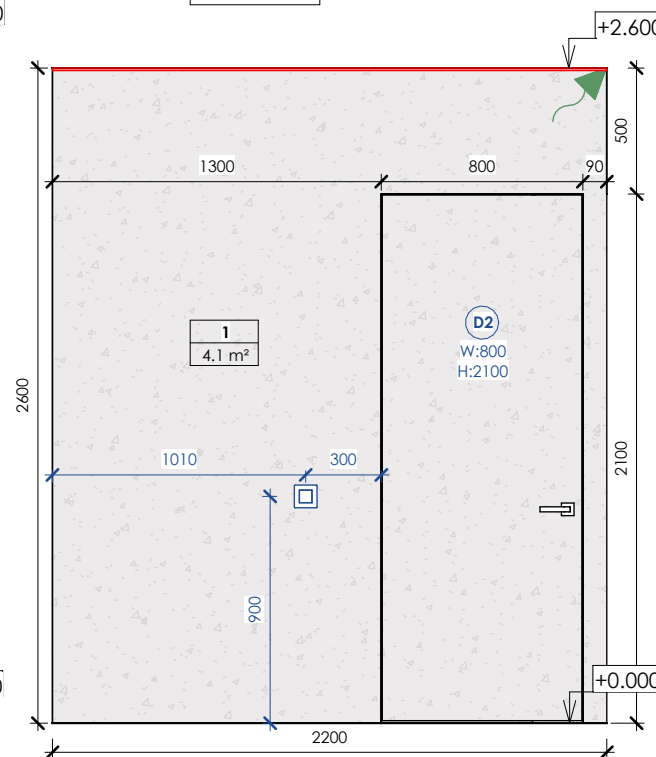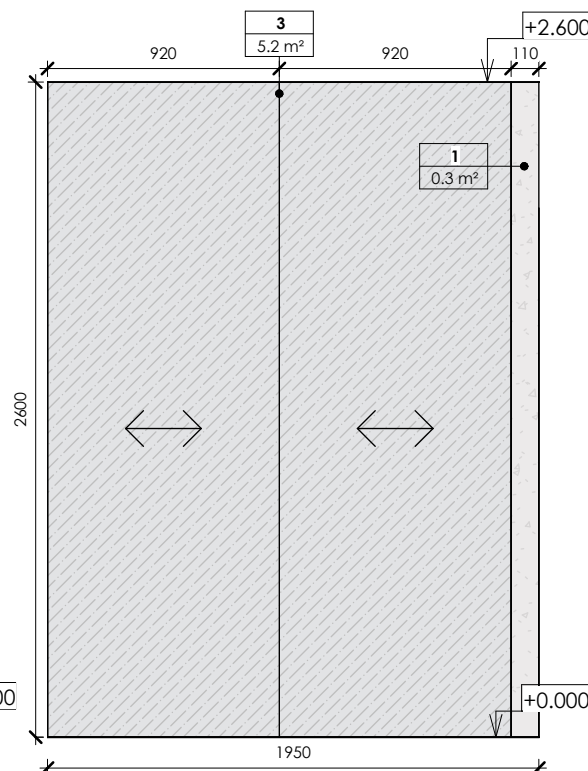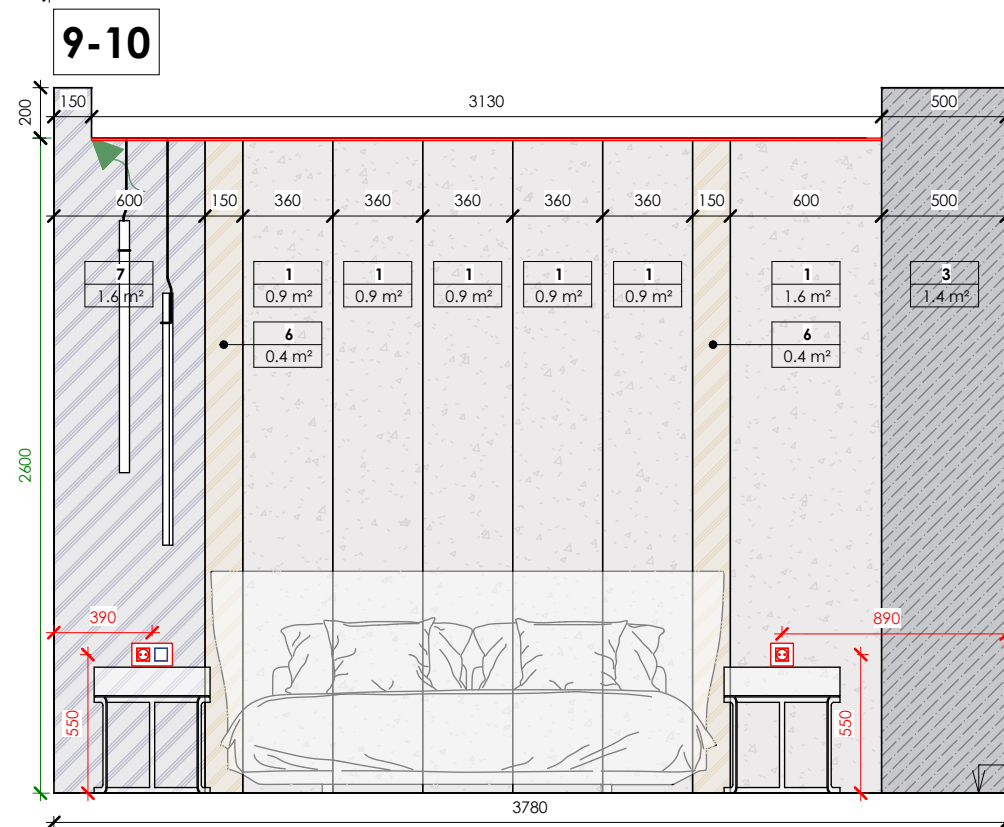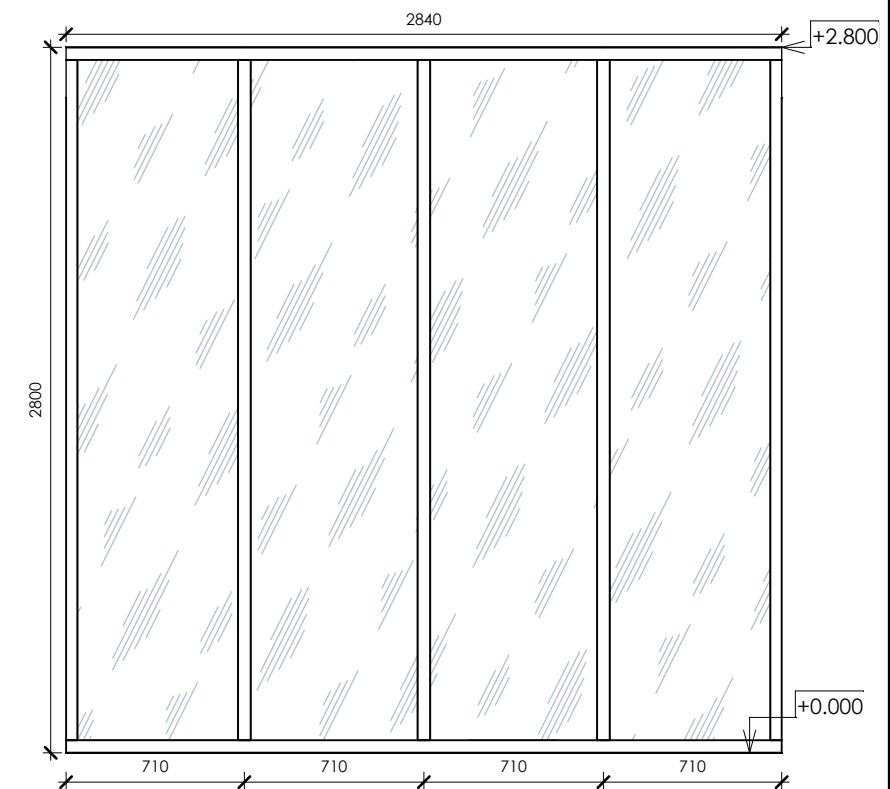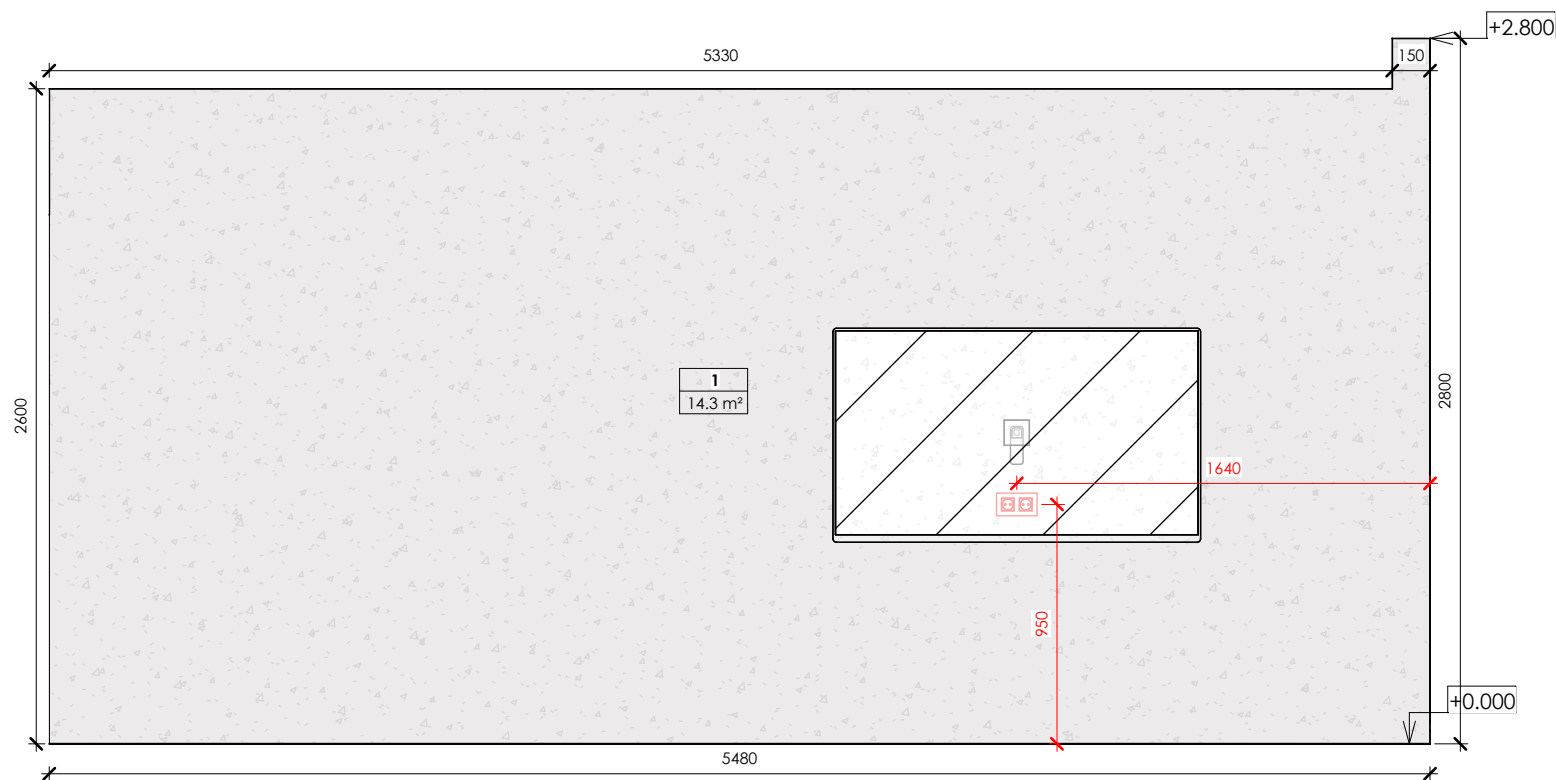

Notes:

1. All dimensions are to be specified on the spot
2. Notify the architect of all discrepancies

Legend :

- LED line
- 220V wire output for LED
- 12V wire output for LED
- One-key switch
- One-key through switch
- Two-key switch
- 220V socket

11-12

General Wall Finish Schedule			
Mark	Finish	Pattern	Total area
1	Decorative plaster (grey)		95 m²
2	MDF panel (dark wood)		7 m²
3	Plaster without finishing (behind furniture)		28 m²

12-13

General Wall Finish Schedule			
Mark	Finish	Pattern	Total area
4	Tile, type 1 (marble imitation)		4 m²
5	Tile, type 2 (wood imitation)		27 m²

13-14

General Wall Finish Schedule			
Mark	Finish	Pattern	Total area
6	MDF panel (bronze)		2 m²
7	MDF panel (silver)		3 m²

14-9

MELASTI ARCADE

Sheet name

Wall elevations


Scale

As indicated


Sheet

A116


SNAAR

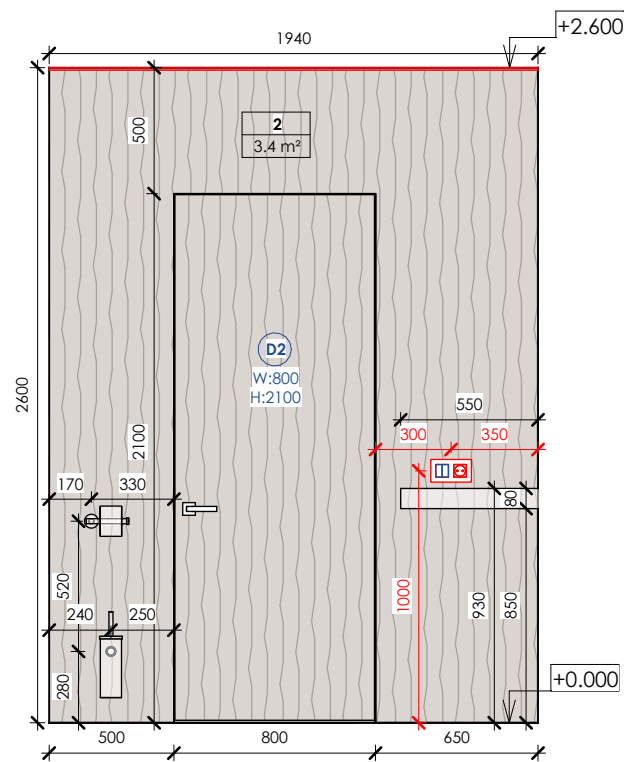


15-16

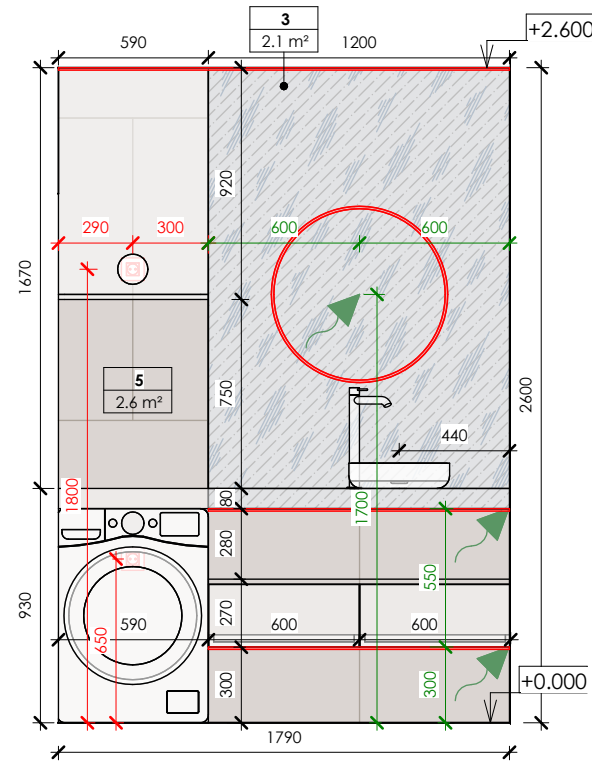


16-17

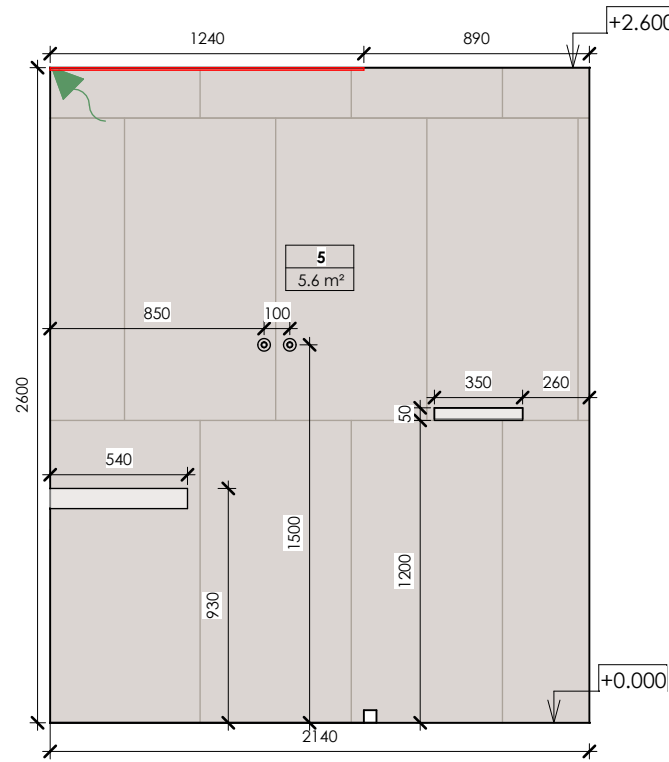


17-18

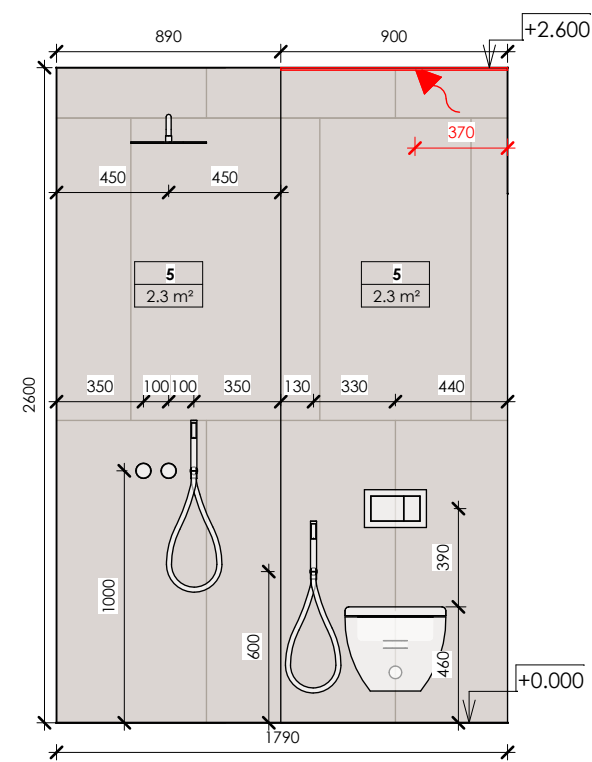


18-15

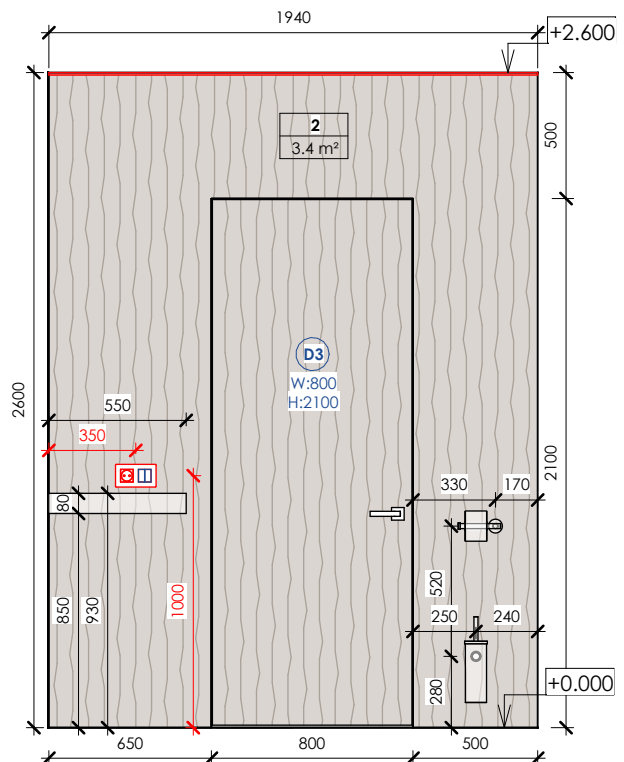


25-26

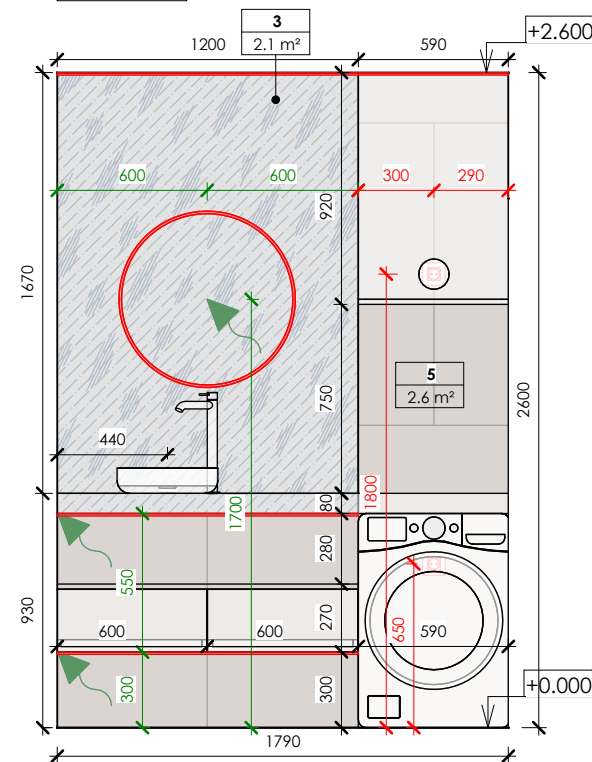

26-27

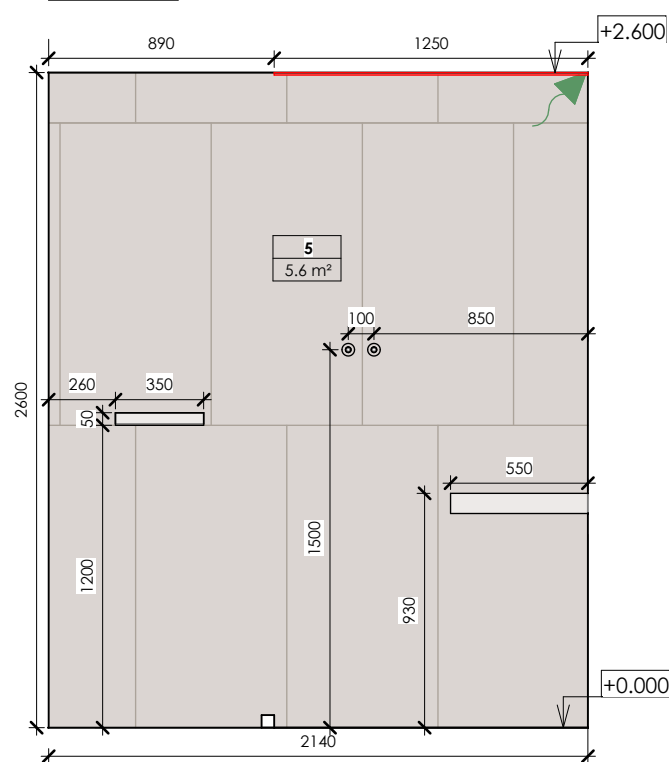

27-28

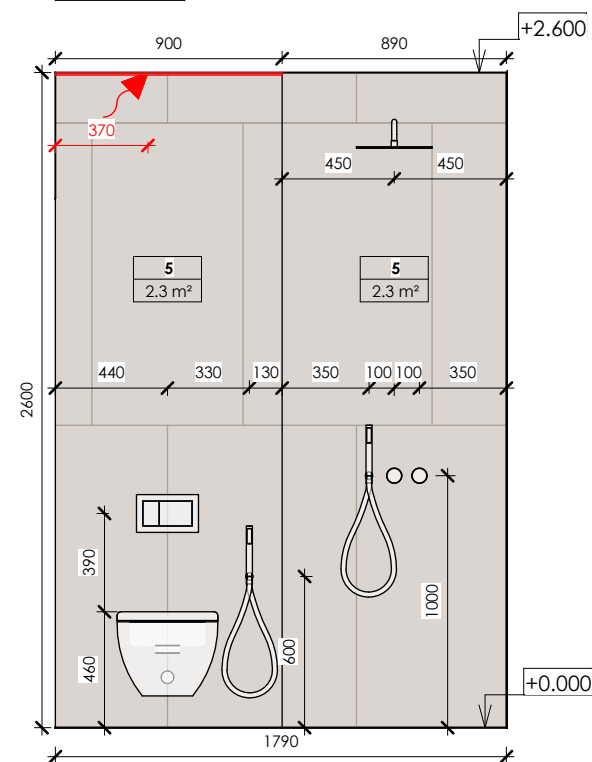

28-25

- Notes:
1. All dimensions are to be specified on the spot
 2. Notify the architect of all discrepancies

Legend :

- LED line
- 220V wire output for LED
- 12V wire output for LED
- One-key switch
- One-key through switch
- Two-key switch
- 220V socket

MELASTI ARCADE

Sheet name

Wall elevations

Scale

As indicated

Sheet

A117

SNAAR

General Wall Finish Schedule


Mark	Finish	Pattern	Total area
1	Decorative plaster (grey)		95 m²
2	MDF panel (dark wood)		7 m²
3	Plaster without finishing (behind furniture)		28 m²

General Wall Finish Schedule


Mark	Finish	Pattern	Total area
4	Tile, type 1 (marble imitation)		4 m²
5	Tile, type 2 (wood imitation)		27 m²

General Wall Finish Schedule

Mark	Finish	Pattern	Total area
6	MDF panel (bronze)		2 m²
7	MDF panel (silver)		3 m²

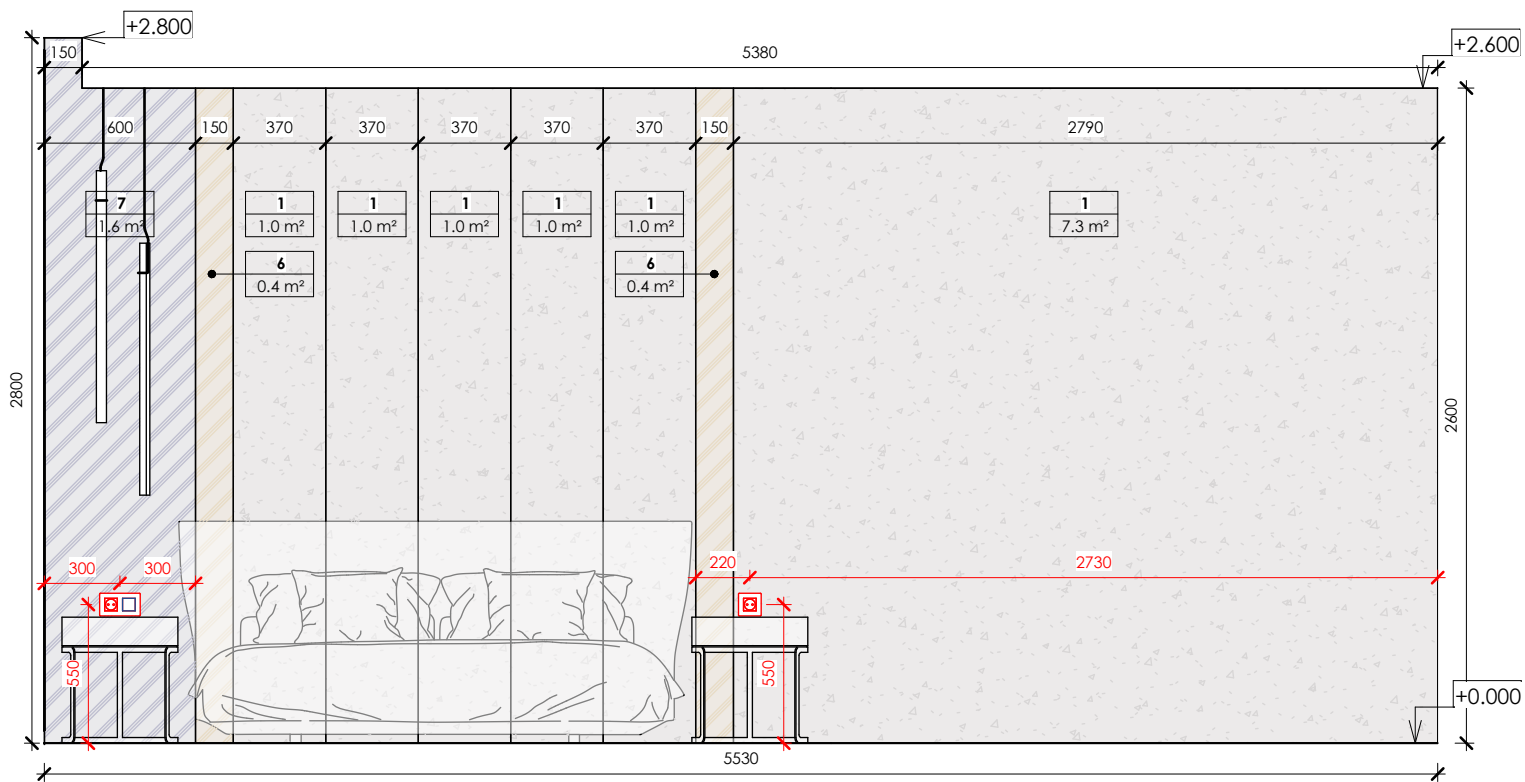


19-20

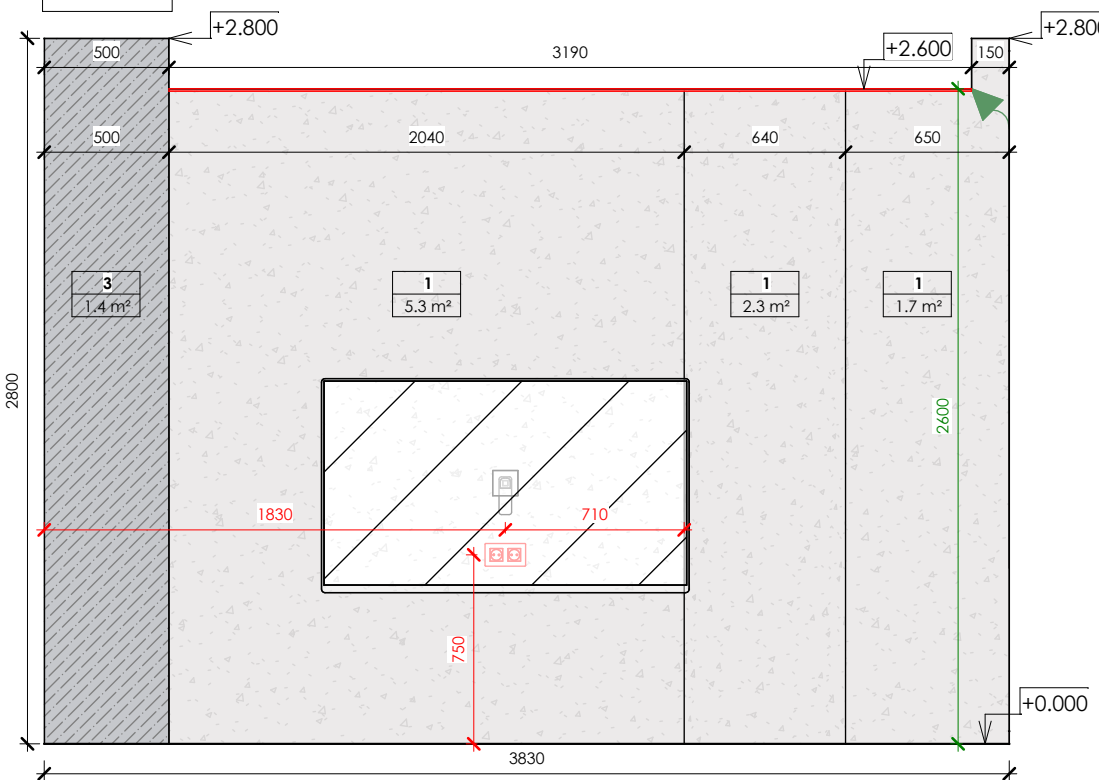


21-22

General Wall Finish Schedule			
Mark	Finish	Pattern	Total area
1	Decorative plaster (grey)		95 m²
2	MDF panel (dark wood)		7 m²
3	Plaster without finishing (behind furniture)		28 m²

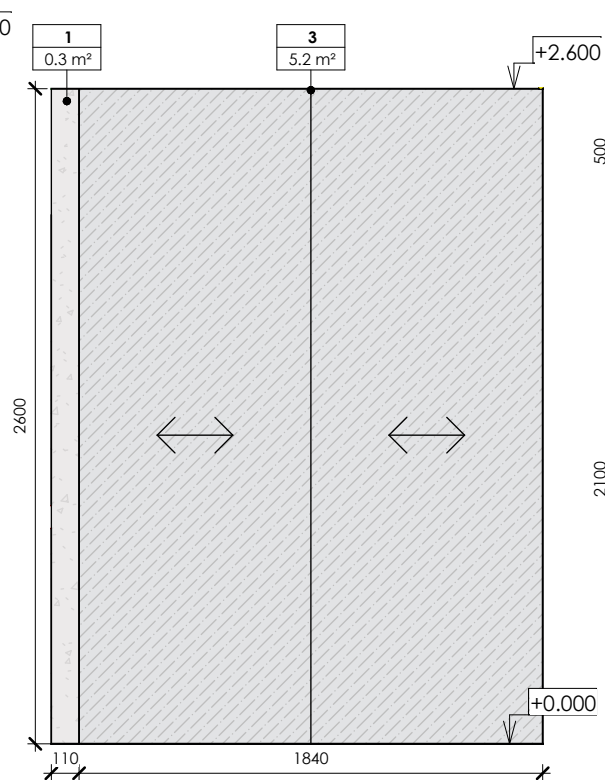


22-23

General Wall Finish Schedule			
Mark	Finish	Pattern	Total area
4	Tile, type 1 (marble imitation)		4 m²
5	Tile, type 2 (wood imitation)		27 m²

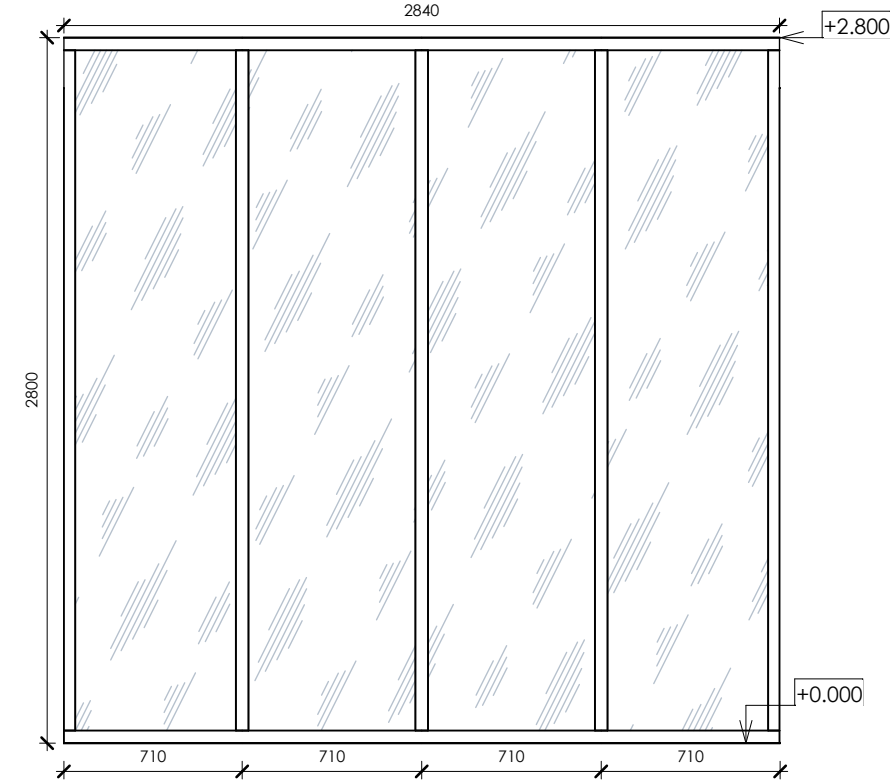


20-21

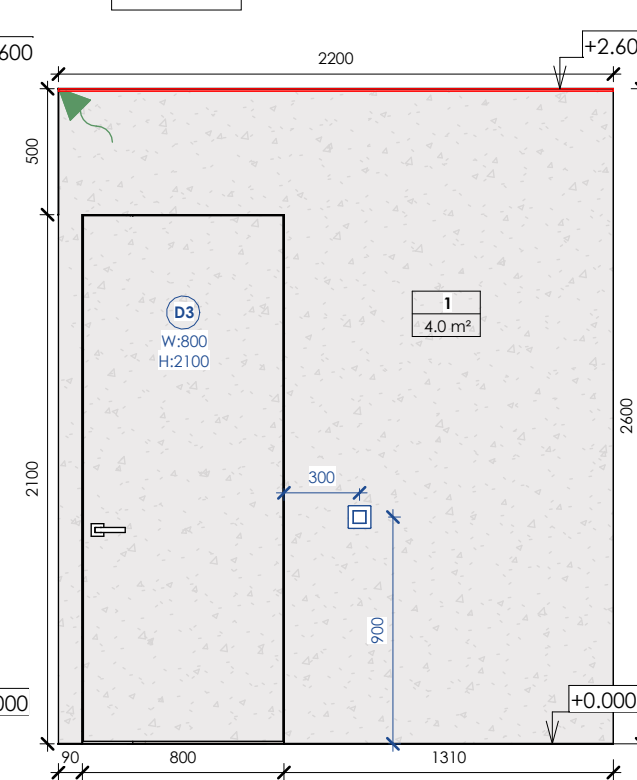

23-24

General Wall Finish Schedule			
Mark	Finish	Pattern	Total area
6	MDF panel (bronze)		2 m²
7	MDF panel (silver)		3 m²

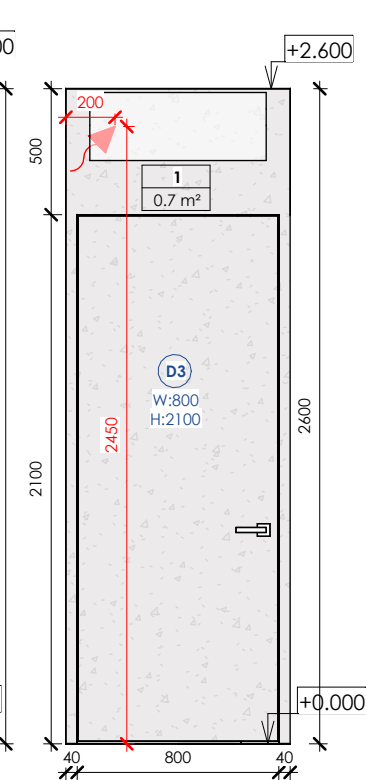

19-24

- Notes:
1. All dimensions are to be specified on the spot
 2. Notify the architect of all discrepancies

Legend :

- LED line
- 220V wire output for LED
- 12V wire output for LED
- One-key switch
- One-key through switch
- Two-key switch
- 220V socket

MELASTI ARCADE

Sheet name

Wall elevations

 

 
Scale

As indicated

Sheet

A118

SNAAR

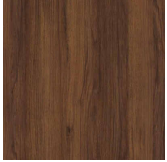Material Takeoff					
Material Name	Image	Manufacturer	Notes	Product Link	Area
Decorative plaster (grey)		CERESIT	CT 35 MAJORCA 1MJ1	https://ceresit.ua/ru/catalog/uteplennyya-fasadiv/ceresit-ct-35.html	99 m²
Glass, type 1		Local market			36 m²
MDF panel (dark wood)		Egger	H1307 ST19 Brown Warmia Walnut	https://www.egger.com/en/furniture-interior-design/decors/H1307_19?country=US	7 m²
Mirror, type 1		Local market			8 m²
Patio board (light wood)		Local market			8 m²
Plaster for painting		Local market	RAL 9010		56 m²
Plaster without finishing (behind furniture)		Local market	RAL 9003		28 m²
Tile, type 1 (grey)		Marvel Grey Stone	1200x1200mm	https://www.atlasconcorde.com/en/ac-collection/marvel/grey-stone	63 m²
Tile, type 2 (wood imitation)		Atlas Concorde Entice Copper Oak Natural	1200x600mm	https://www.atlasconcorde.com/en/ac-collection/entice	27 m²

MELASTI ARCADE

Sheet name



Specifications

Scale

Sheet
A119

SNAAR

Lighting Fixture Specification						
Symbol	Product Name	Manufacturer	Product Code	Product Photo	Product Link	Count
	LED	Philips	Philips Hue LightStrips Plus		https://www.philips-hue.com/en-us/p/hue-white-and-color-ambi	30
	Pendant light, type 1	VIBIA	Halo jewel		https://vibia.com/en/int/collections/hanging-lamps-halo-jewel-hanging	4
	Chandelier, type 1	Bocci	100 RANDOM		https://bocci.com/shop/products/100-3-random/	1
	Sconce, type 1	Regina Andrew	Redford Sconce		https://www.reginaandrew.com/Redford-Sconce?quantity=1&custcolfinishmatrix=1&custcol_bulb_item=35042&custcol_bulb_qty=2&srltid=AfmBOoqHYMmcf4dOixZ803hcpy9x2-Sqvha8iQDQ6nCpnFfRfFNi1nbJ	2
	Floor lamp	PK Green	Ball Floor Lamp		https://www.pkgreenshop.co.uk/products/40cm-glowing-sphere-light-event-wedding-led-lighting-warm-white?currency=GBP&utm_source=google&utm_medium=cpc&utm_campaign=Google%20Shopping&stkn=bb2c80bf1dbe	3

  Electrical Specification						
Symbol	Product Name	Manufacturer	Product Code	Product Photo	Product Link	Count
	Frame 1-post	Schneider Electric	EPH5800171		https://elektronik.kiev.ua/index.php/shop/rostki-i-vik-2/rozetki-i-vik-schneider/schnaider-asfora/asfora-ant ratsit/ramka-schneider-shnajder-asfora-plus-1-post-gorizontalnaya-antratsit	12
	Frame 2-post	Schneider Electric	EPH5800271		https://elektronik.kiev.ua/index.php/shop/rostki-i-vik-2/rozetki-i-vik-schneider/schnaider-asfora/asfora-ant ratsit/ramka-schneider-shnajder-asfora-plus-2-postovaya-gorizontalnaya-antratsit	9
	220V Socket	Schneider Electric	EPH2900171		https://elektronik.kiev.ua/index.php/shop/rostki-i-vik-2/rozetki-i-vik-schneider/schnaider-asfora/asfora-ant ratsit/rozetka-schneider-shnajder-asfora-plus-s-zazemleniem-antratsit	19
	Two-key switch	Schneider Electric	EPH0300171		https://elektronik.kiev.ua/index.php/shop/rostki-i-vik-2/rozetki-i-vik-schneider/schnaider-asfora/asfora-ant ratsit/pereklyu chatel-schneider-shnajder-asfora-plus-2-klavishnyj-prokhodnoj-antratsit	2
	One-key switch	Schneider Electric	EPH0100171		https://elektronik.kiev.ua/index.php/shop/rostki-i-vik-2/rozetki-i-vik-schneider/schnaider-asfora/asfora-ant ratsit/vyklyuch atel-schneider-shnajder-asfora-plus-1-klavishnyj-antratsit	6
	One-key through switch	Schneider Electric	EPH0100171		https://elektronik.kiev.ua/index.php/shop/rostki-i-vik-2/rozetki-i-vik-schneider/schnaider-asfora/asfora-ant ratsit/vyklyuch atel-schneider-shnajder-asfora-plus-1-klavishnyj-antratsit	2

MELASTI ARCADE

Sheet name

 
 
Specifications

Scale

Sheet

A120

SNAAR

General Specification						
Product Name	Manufacturer	Product Code	Dimensions	Product Photo	Product Link	Count
Air conditioner	LG	LG PC24SQ	W: 820 D: 200 H: 270mm		https://www.lg.com/ua/aircon/lg-pc24sq	3
Armchair, type 1	Minotti	Vivienne "Dining"	W: 500 D: 650 H: 800mm		https://www.minotti.com/en/vivienne-dining	4
Armchair, type 2	Minotti	Halley "Outdoor"	W: 650 D: 800 H: 420mm		https://www.minotti.com/en/halley-outdoor_2	2
Bed	B&B	Alys	W: 1900 L: 2150 H: 890mm		https://www.bebitalia.com/en-us/en-aly-letti.html	2
Bedside table	Deveno	Mut	D(W): 450 H: 500mm		https://deveno.ru/mebel/tumbi/tumba-mut-by-deveno	4
Boiler	Bosch	Tronic 3500	W: 600 D: 300 H: 920mm		https://bosch-centre.com.ua/ploskyi-elektrychnyi-boiler-bosch-tronic-3500-tr3501-100-ebp-7736507294	2
Coffee table, type 1	Gallotti&Radice	Haumea	D(W): 800 H: 300mm		https://www.gallottiradice.it/en-us/products/haumea	1
Coffee table, type 2	Gallotti&Radice	Haumea	D(W): 500 H: 380mm		https://www.gallottiradice.it/en-us/products/haumea	1
Coffee table, type 3	Molteni	Louisa	D(W): 700* H: 280mm		https://www.molteni.it/en/product/louisa	1
Commode	Local market		W: 2620 D: 400 H: 300mm			1
Exhaust fan	Ergovent	Rondo	Diameter: 150mm		https://bt-service.ua/uk/cata-e-100-gsth-00900600?gclid=Cj0KCQjwurS3BhCGARIsADdUH52mmawi1bXk5XSdo2lpZV-Mwvwy7stcUgdBfr6vSjmYs1NUkn4DugoaAlalEALw_wcB	2

MELASTI ARCADE

Sheet name

Specifications


Scale

Sheet

A121

SNAAR

General Specification

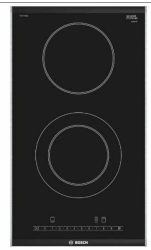Product Name	Manufacturer	Product Code	Dimensions	Product Photo	Product Link	Count
Faucet	Aliceceramica	22440101	H: 360*mm		https://www.aliceceramica.com/en/collezioni/form-washbasin-oval-60x35-h15/	2
Fridge	Bosch	KIS87AF30U	W: 600 D: 570 H: 1900mm		https://www.bosch-home.com.ua/ru/mkt-product/holodilniki-i-morozilniki/holodilnyki/vstroennij-holodilnyk-s-nizhnej-morozilnoj-kameroj/KIS87AF30U	1
Glass panel	Local market		W: 900 H: 2500mm			4
Hob	Bosch	PKF375FP1E	W: 300 D: 500mm		https://ukraine-bosch.com/bosch-pkf375fp1e-181038.html	1
Hood	Falmec	Mercurio 60	W: 600 D: 450 H: 1000mm		https://falmec.kiev.ua/falmec_mercurio_60_stainless_steel_600	1
Hygienic shower	Gessi	Gessi 316 Set Douche	Connection diameter: 60mm		https://dwellistore.fr/gessi-316-ensemble-douche-54023.html?srltid=AfmBOoqAy2_yHcq2LuLdhdBeNtinHxQDVy58sAwRgPhgrtyyD0rnN-PwdP8	4
Microwave	Bosch	BFL623MC3	W: 600 D: 350 H: 400mm		https://www.bosch-home.com.ua/ru/mkt-product/prigotovlenije/mikrovolnoviye-pechi/vstroennaya-mikrovolnovka/BFL623MC3	1

MELASTI ARCADE

Sheet name


 
Specifications

Scale

Sheet

A122

SNAAR

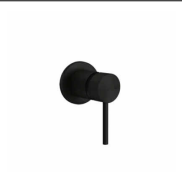General Specification						
Product Name	Manufacturer	Product Code	Dimensions	Product Photo	Product Link	Count
Mirror	Local market		W: 1200 H: 1670mm			2
Mixer	Gessi	Gessi316 54019299	Diameter: 60mm		https://budcamp.com.ua/products/zmishuvach-dlya-vanni-gessi-gessi316-54019299	4
Shower head	Gessi	Gessi316 (54148-239)	Diameter: 300mm		https://home-fashion.com.ua/verkhniy-dush-gessi-316-shower-54148-239/	2
Sink mixer	Gessi	Stelo 60315	H: 360*mm		https://www.gessi.com/en/kitchen/stelo	1
Sink, type 1	Aliceceramica	22440101	D(W): 400* H: 200mm		https://www.aliceceramica.com/en/collezioni/form-washbasin-oval-60x35-h15/	2
Sink, type 2	Blanco	Etagon	W: 600 D: 440 H: 200mm		https://www.blanco.co.uk/sinks/etagon/blancoetagon500-uifino_232.752/52775	1
Sofa	Minotti	Goodman	W: 2470 D: 1150 H: 665mm		https://www.minotti.com/en/goodman#	1
Table	Poliform	ADRIEN	D(W): 1400 H: 740mm		https://www.poliform.it/en-us/products/adrien/	1
Toilet	NIC	VASO SOSPESO SEMPLICE RIMLESS cod. 003 699	W: 400 D: 550 H: 330mm		https://www.nicdesign.it/it/arredo-bagno/sanitari-wc-bidet/wc-e-bidet-sospesi/semplice-wc-e-bidet-sospesi_18.htm	2
TV 65"	LG	65QNED80UQA	<varies>		https://www.lg.com/us/tvs/lg-65qned80uqa-qned-4k-tv	3
TV cabinet	Local market		W: 2620 D: 100 H: 1100mm			1

MELASTI ARCADE

Sheet name

Specifications

Scale

Sheet

A123

SNAAR