


List of working drawings	
Sheet Number	Sheet Name
A100	Project Information
A101	Construction plan
A102	Installation plan
A103	Measurement plan
A104	Furniture layout
A105	Plumbing plan
A106	Floor finish plan
A107	Ceiling finish plan
A108	Lighting plan
A109	Lighting groups plan
A110	Sockets & electrical output layout
A112	Wall finish plan
A113	Marking plan
A114	Wall elevations
A115	Wall elevations
A116	Wall elevations
A117	Specifications
A118	Specifications
A119	Specifications
A120	Specifications

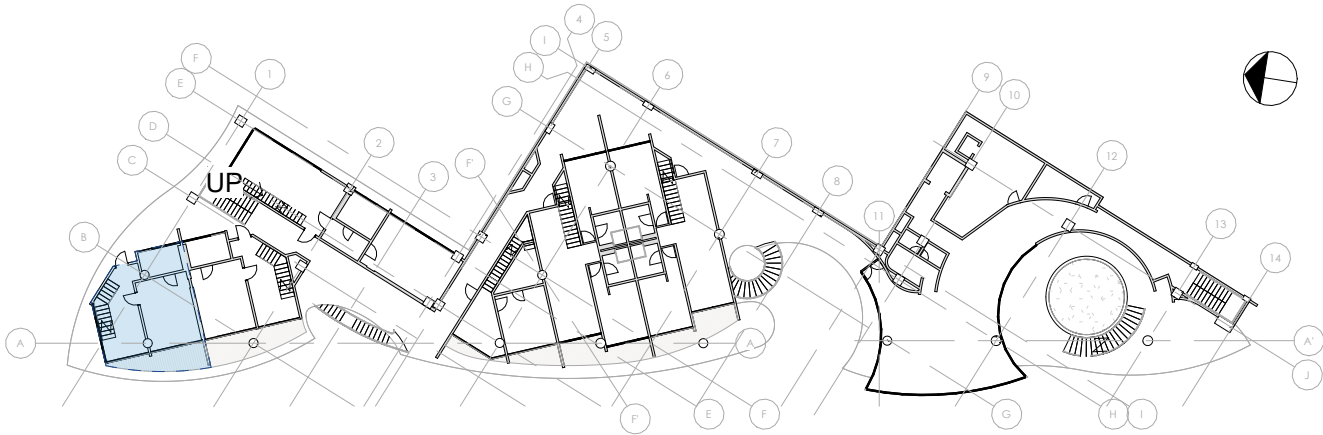

Key Plan Pent #4

1 : 500

Notes:

1. It is allowed to make changes to the Design project during the implementation process, subject to agreement with the architect.

2.The visualizations in this album are a conditional indicative image of the finished object and should be considered together with the drawings and equipment.

3.Non-standard structures, complex elements and structural units are developed by the relevant contractor on the basis of the technical specifications issued by the architect

MELASTI ARCADE

Sheet name
Project Information


Scale
1 : 500

Sheet
A100

SNAAR

Construction

1 : 50

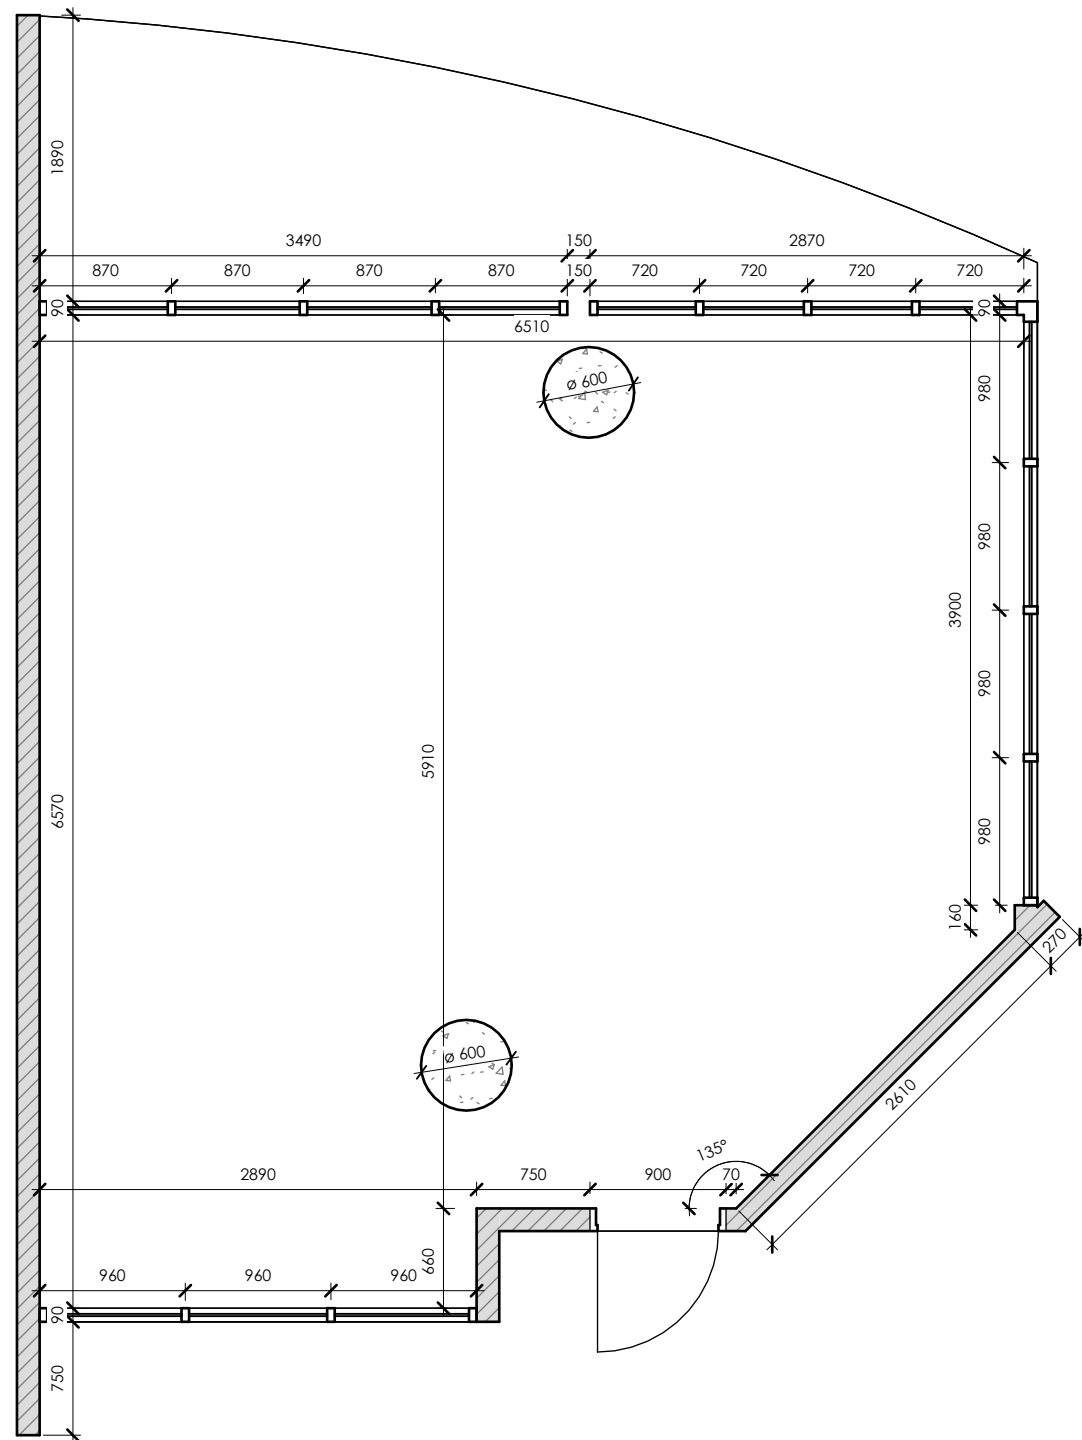

Notes:

1. All dimensions are design. Before ordering, manufacturing, installation, it is imperative to perform actual measurements.
2. The color and texture of the materials are agreed only on real samples.
3. In case of changes in dimensions or position in space, coordinate with the project architect.

MELASTI ARCADE

Sheet name

Construction plan


Scale
1 : 50

Sheet
A101

SNAAR

Installation

1 : 50

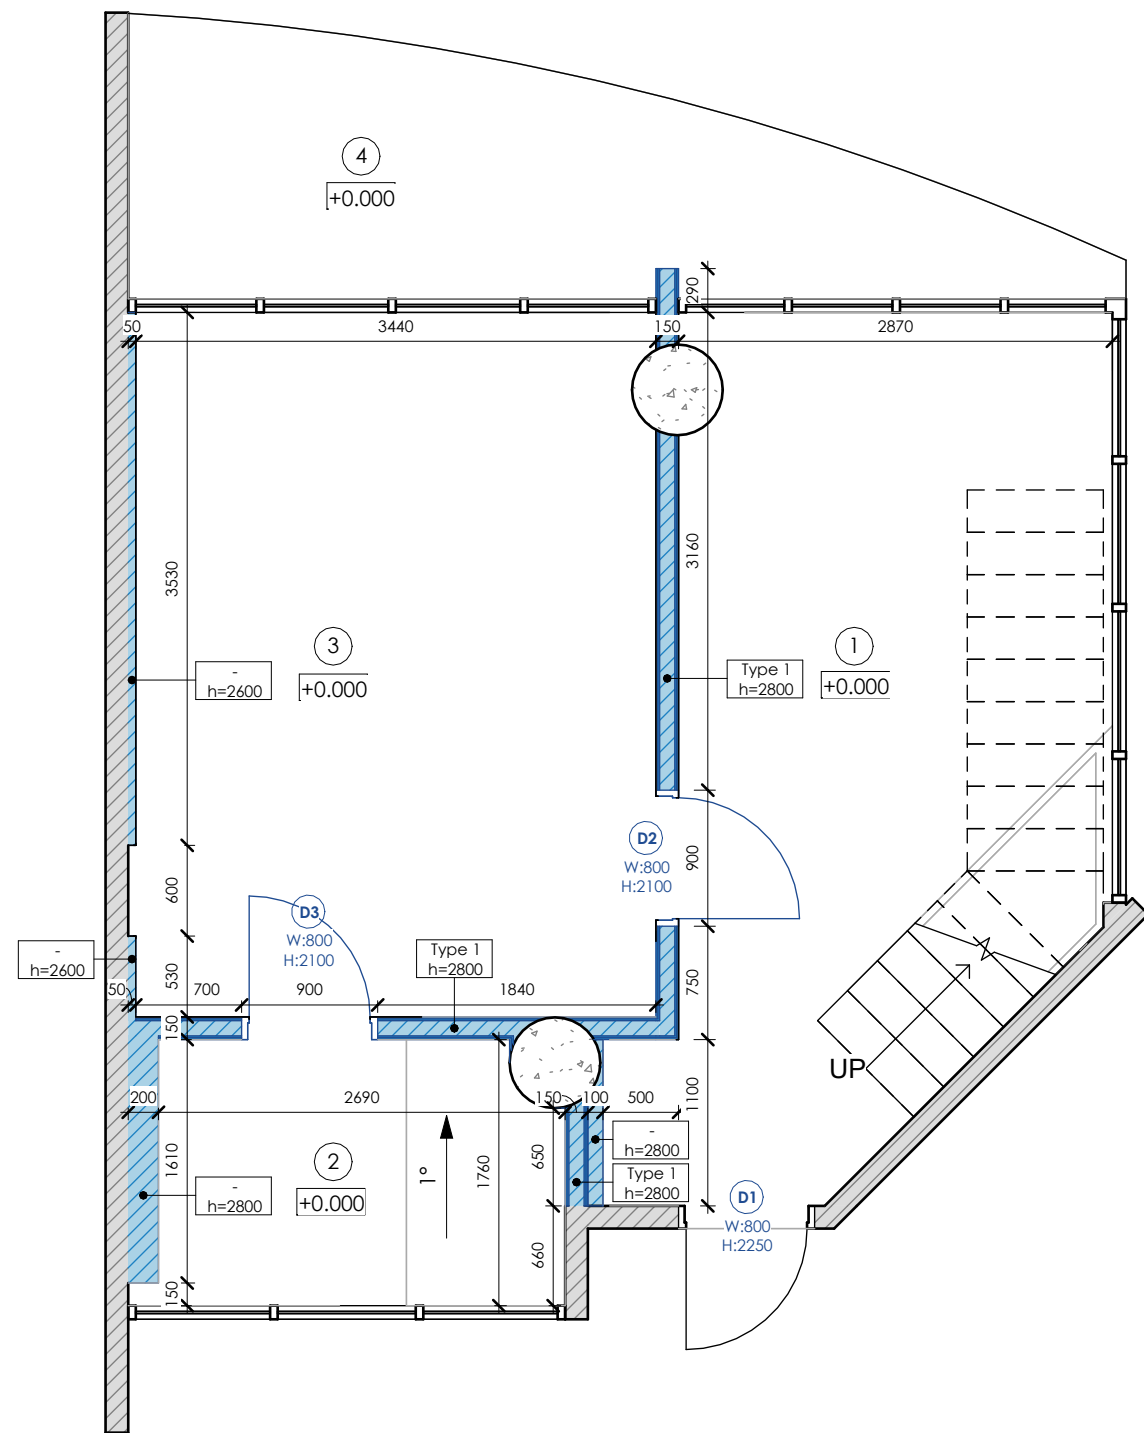

Wall Schedule

Mark	On the plan	Description	Thickness	Volume
Type 1		Aluminium profile 125mm - Drywall 12.5mm, 2 sheet, two sides	350 mm	3.55 m³

Door Schedule

Mark	Count	Description	Opening type	Finish inside	Finish outside
D1	1	Concealed installation door 800x2250mm (clear canvas)	Left hand/outside	Decorative plaster (grey)	-
D2	1	Concealed installation door 800x2100mm (clear canvas)	Left hand/outside	Decorative plaster (grey)	Decorative plaster (grey)
D3	1	Concealed installation door 800x2100mm (clear canvas)	Right hand/outside	MDF panel (dark wood)	Decorative plaster (grey)

Room Schedule

Nº	Name	Area
Level 3		
1	Living room	15.8 m²
2	Bathroom	5.1 m²
3	Bedroom	16.2 m²
4	Terrace	8.8 m²
		45.8 m²
Roof top		
5	Roof top	68.6 m²
		68.6 m²
Total area:		114.4 m²

Notes:

1. All dimensions are design. Before ordering, manufacturing, installation, it is imperative to perform actual measurements.
2. The color and texture of the materials are agreed only on real samples.
3. In case of changes in dimensions or position in space, coordinate with the project architect.

MELASTI ARCADE

Sheet name

Installation plan

Scale

1 : 50


Sheet

A102

SNAAR

Measurement

1 : 50

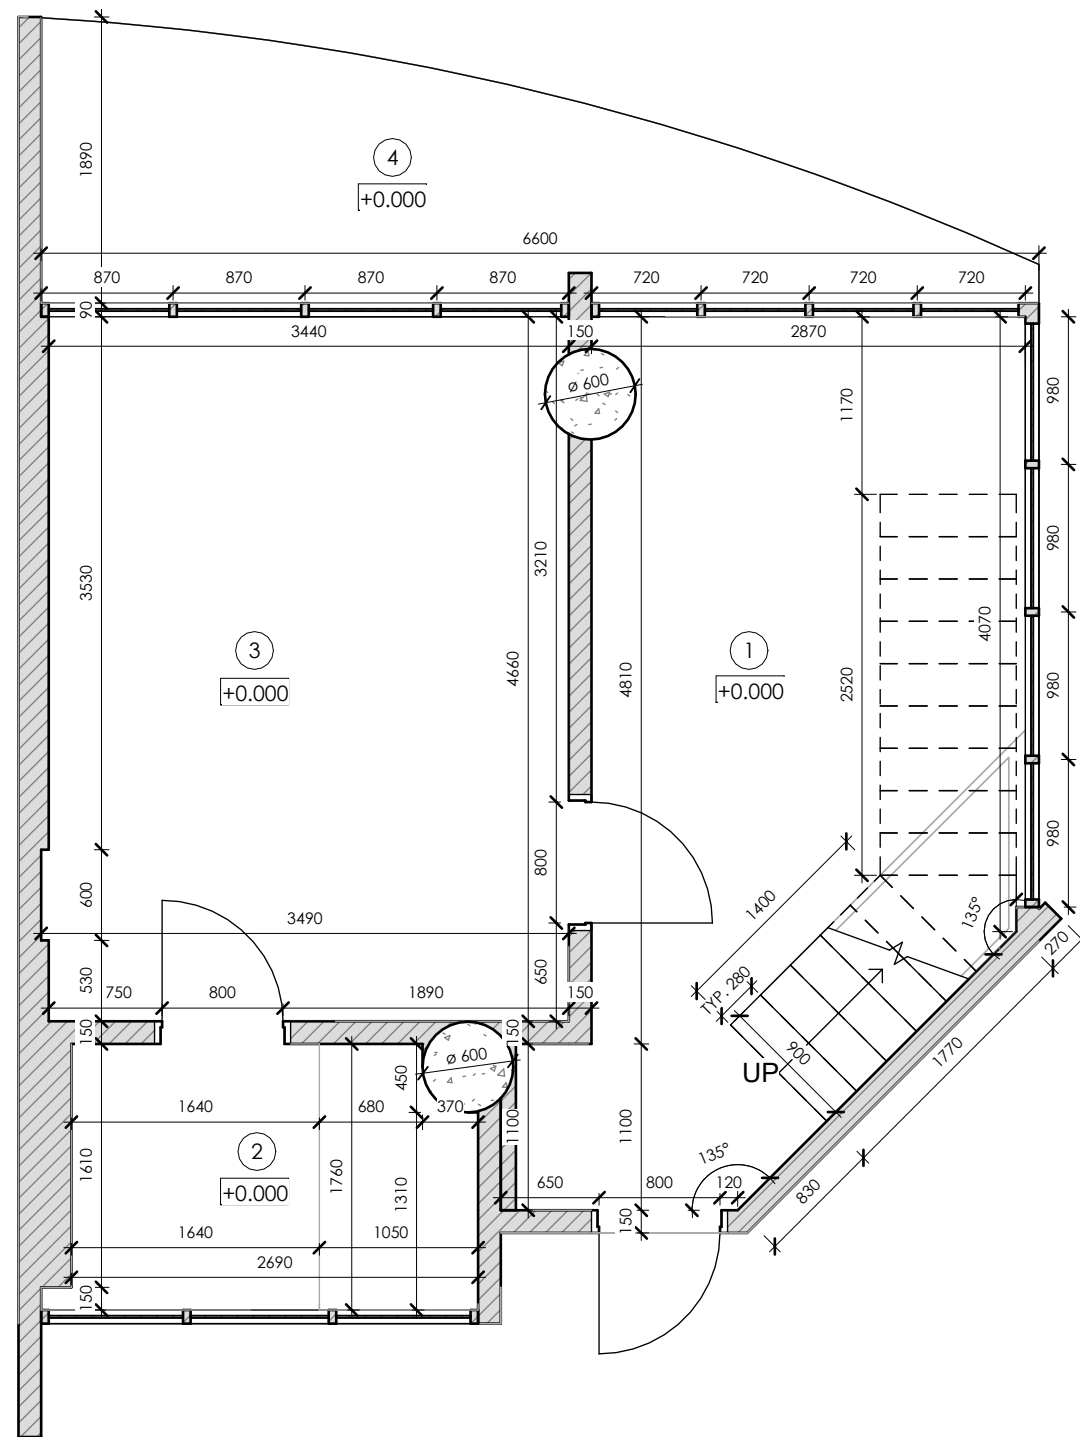

Room Schedule		
Nº	Name	Area
Level 3		
1	Living room	15.8 m²
2	Bathroom	5.1 m²
3	Bedroom	16.2 m²
4	Terrace	8.8 m²
		45.8 m²
Roof top		
5	Roof top	68.6 m²
		68.6 m²
Total area:		114.4 m²

- Notes:
1. The contractor develops detailed drawings and coordinates the content and dimensions with the architect of the project.
 2. All dimensions are design. Before ordering, manufacturing, installation of furniture, it is imperative to perform actual measurements.
 3. The color and texture of the materials are agreed only on real samples.
 4. In case of changes in dimensions or position in space, coordinate with the project architect.

MELASTI ARCADE

Sheet name
Measurement plan


Scale
1 : 50

Sheet
A103

SNAAR

Furniture

1 : 50

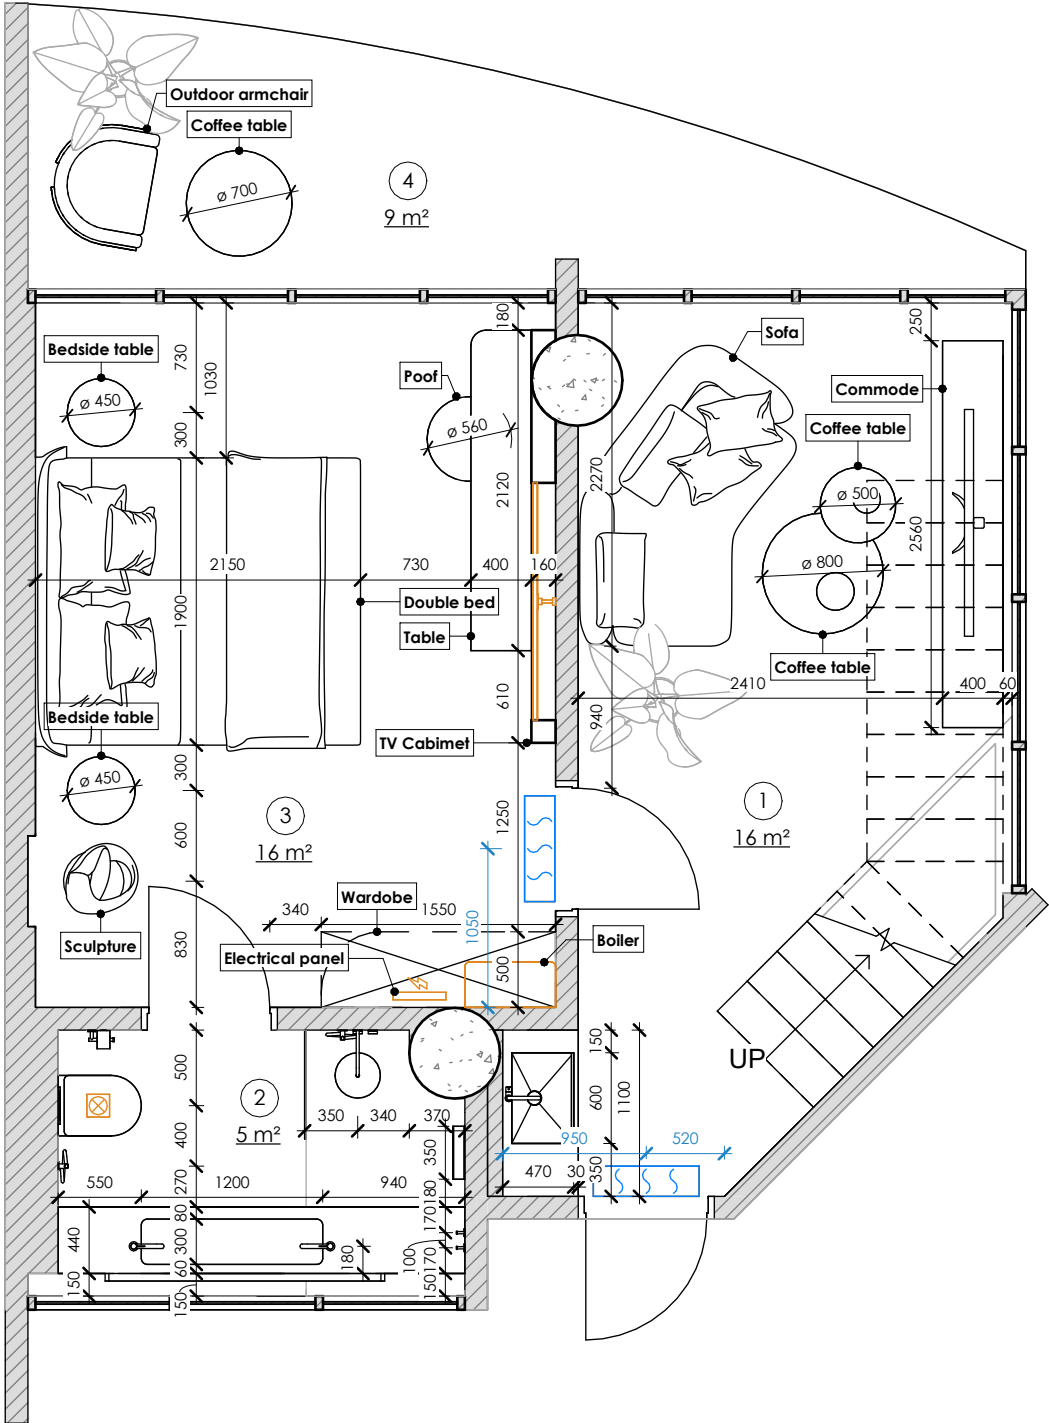

Room Schedule		
Nº	Name	Area
Level 3		
1	Living room	15.8 m²
2	Bathroom	5.1 m²
3	Bedroom	16.2 m²
4	Terrace	8.8 m²
		45.8 m²
Roof top		
5	Roof top	68.6 m²
		68.6 m²
Total area:		114.4 m²

- Notes:
1. The contractor develops detailed drawings and coordinates the content and dimensions with the architect of the project.
 2. All dimensions are design. Before ordering, manufacturing, installation of furniture, it is imperative to perform actual measurements.
 3. The color and texture of the materials are agreed only on real samples.
 4. In case of changes in dimensions or position in space, coordinate with the project architect.
 5. Dimensions marked with "*" are approximate values. For clarification, see the "Specifications" sheet.

MELASTI ARCADE

Sheet name
Furniture layout



Scale
1 : 50

Sheet
A104



SNAAR

Bathroom/ Kitchen

1 : 20

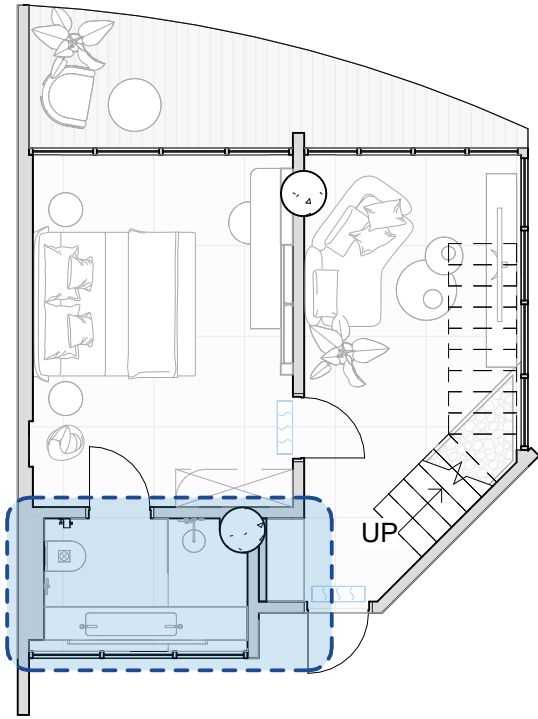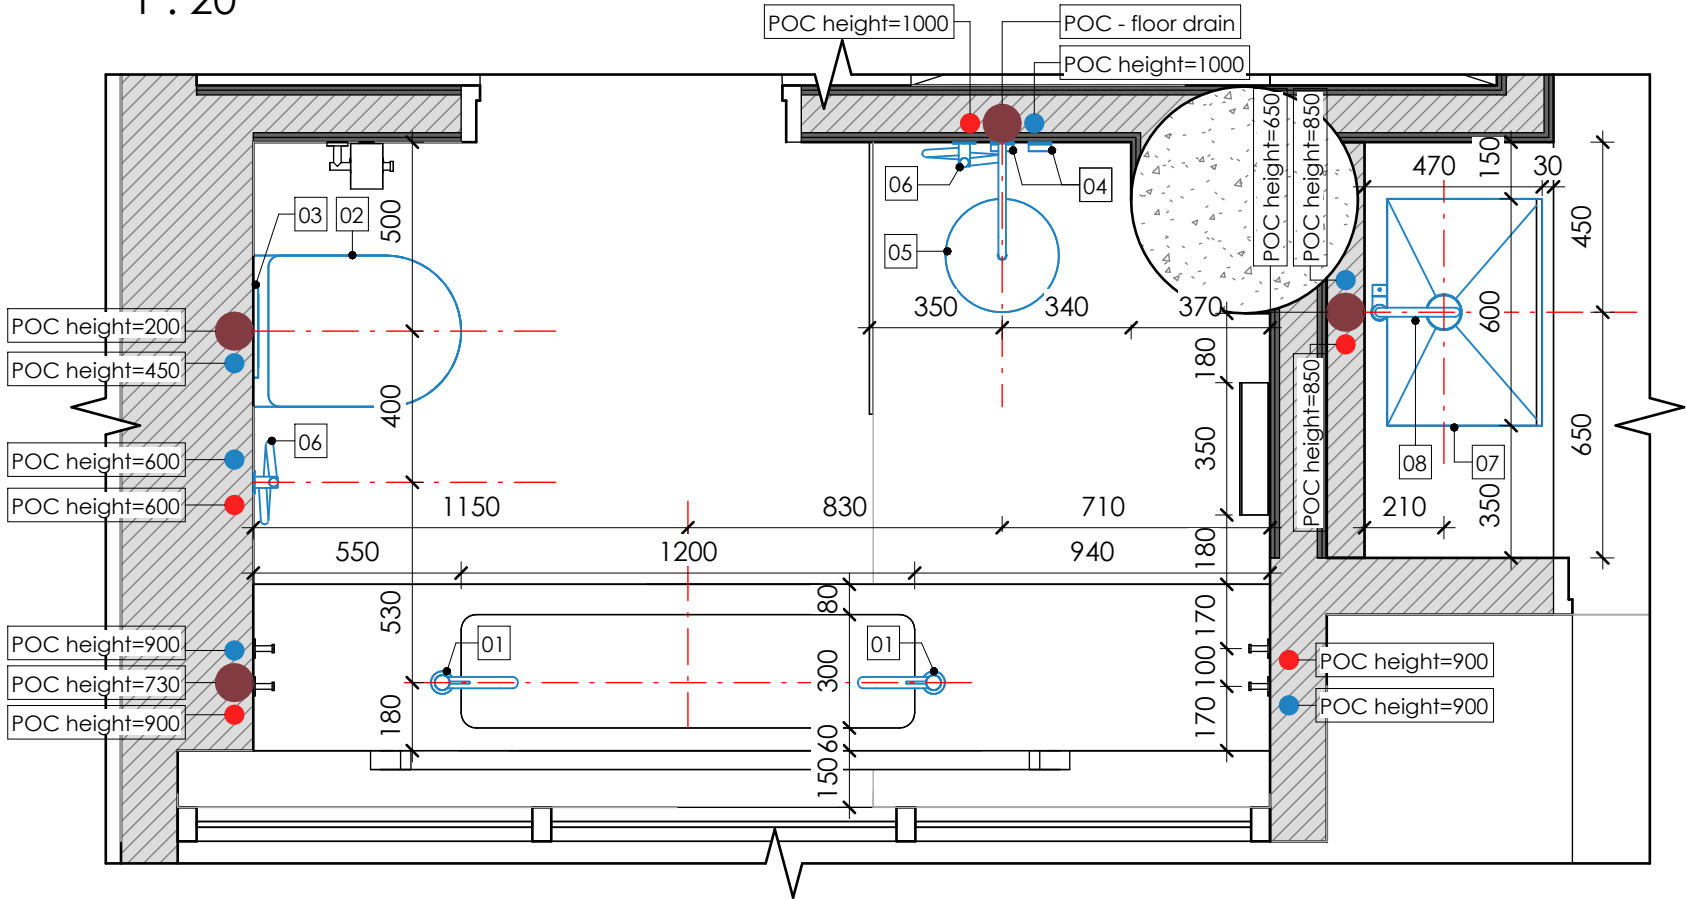

Plumbing Fixture Schedule			
Mark	Symbol	Description	Count
01		Faucet h.360	2
02		WC wall-hung	1
03		Rectangular drain button	1
04		Valve	2

  Plumbing Fixture Schedule			
Mark	Symbol	Description	Count
05		Tropical showerhead	1
06		Hygienic showerhead	2
07		Kitchen undermounted sink	1
08		Kitchen faucet h.360	1

- Notes:
1. Dimensions do not include plaster and wall finishes, the dimensions must be clarified upon actual
 2. Carify the connection according to the technical cards of the installed plumbing fixtures
 3. Models of sanitary equipment can be specified during the design process
 4. All inspection hatches of concealed installation in the finish of the wall on which they are located (specify the location)
 5. Dimensions marked with "*" are approximate values. For clarification, see the "Specifications" sheet.

Legend :

-  Domestic hot water
-  Domestic cold water
-  Sanitary waste

MELASTI ARCADE

Sheet name

Plumbing plan

Scale

As indicated


Sheet

A105

SNAAR

Floor finish

1 : 50

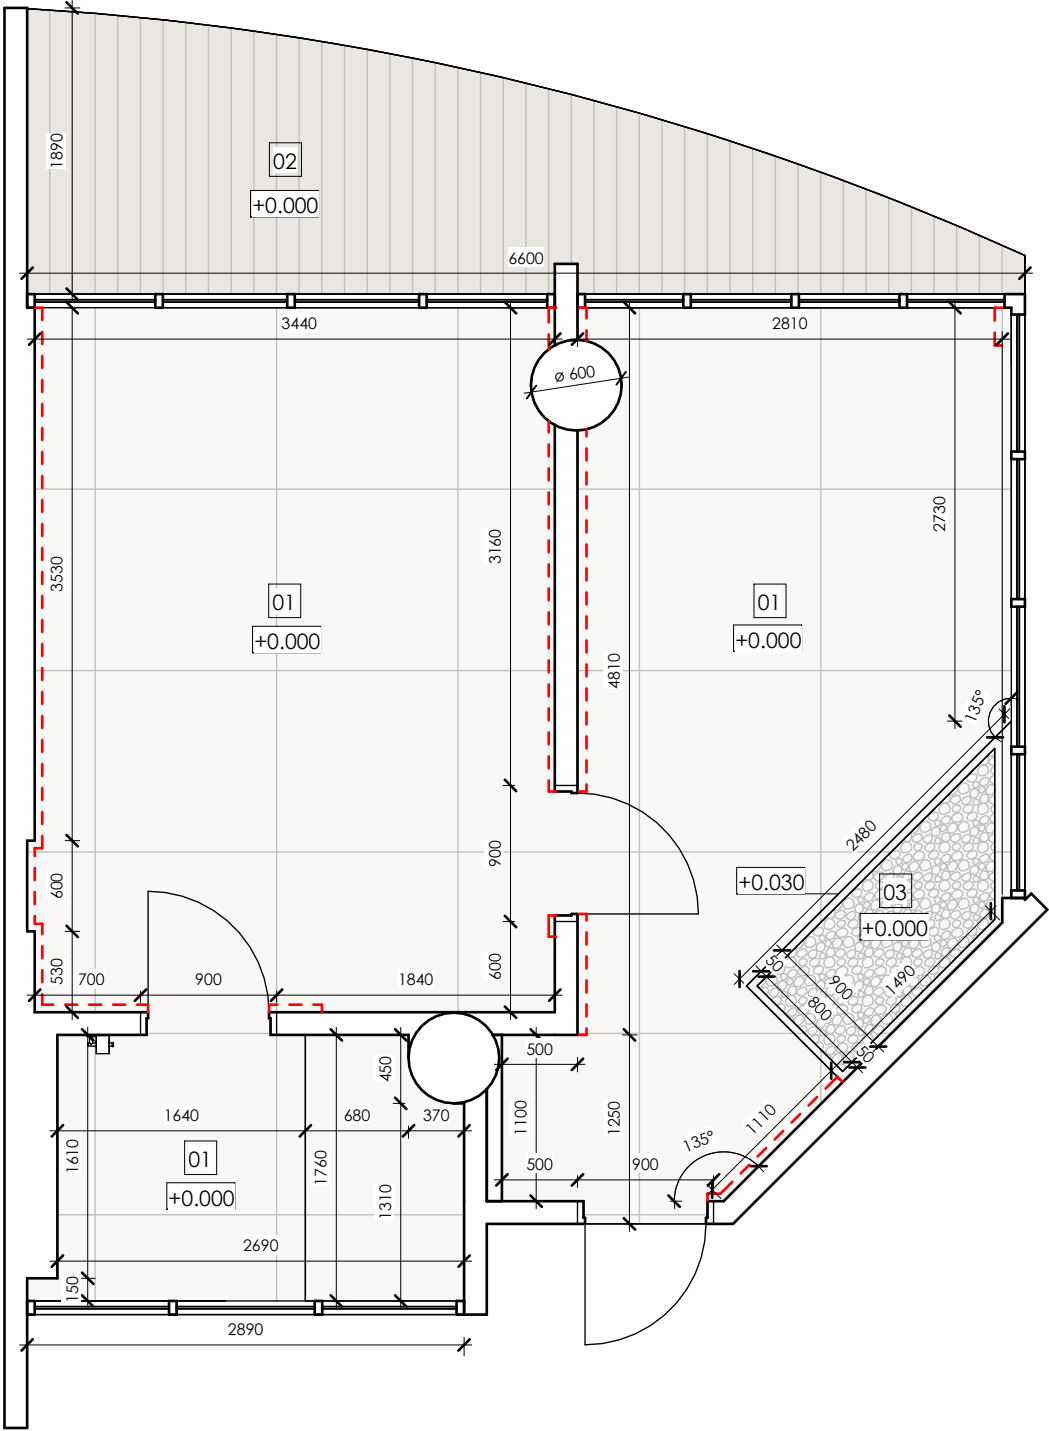

Floor Schedule

Mark	Description	Material	On the plan	Appearance	Area
01	Tile type 1 (marble imitation)	Stoneware			35.3 m²
02	Patio board (light wood)	Wood			8.5 m²
03	Gravel				1.5 m²

Total area: 45.3 m²

Hidden skirting board Schedule

Mark	Image	Length
SB-1		15 m

Legend :

--- Hidden skirting board

- Notes:
1. The area of materials is indicated without trimming and stock. Recommended stock amount - 15%
 2. Finishing materials are agreed separately with samples
 3. Floor joints should be made strictly under the bottom of the interior doors leaves
 4. Before laying the floor coverings, lay out dry and adjust the offset
 5. Dimensions are indicated without wall coverings
 6. Important! Dimensions are indicated for preliminary calculation, proceed with installation only after control measurements.

MELASTI ARCADE

Sheet name

Floor finish plan

Scale

As indicated


Sheet

A106

SNAAR

Ceiling

1 : 50

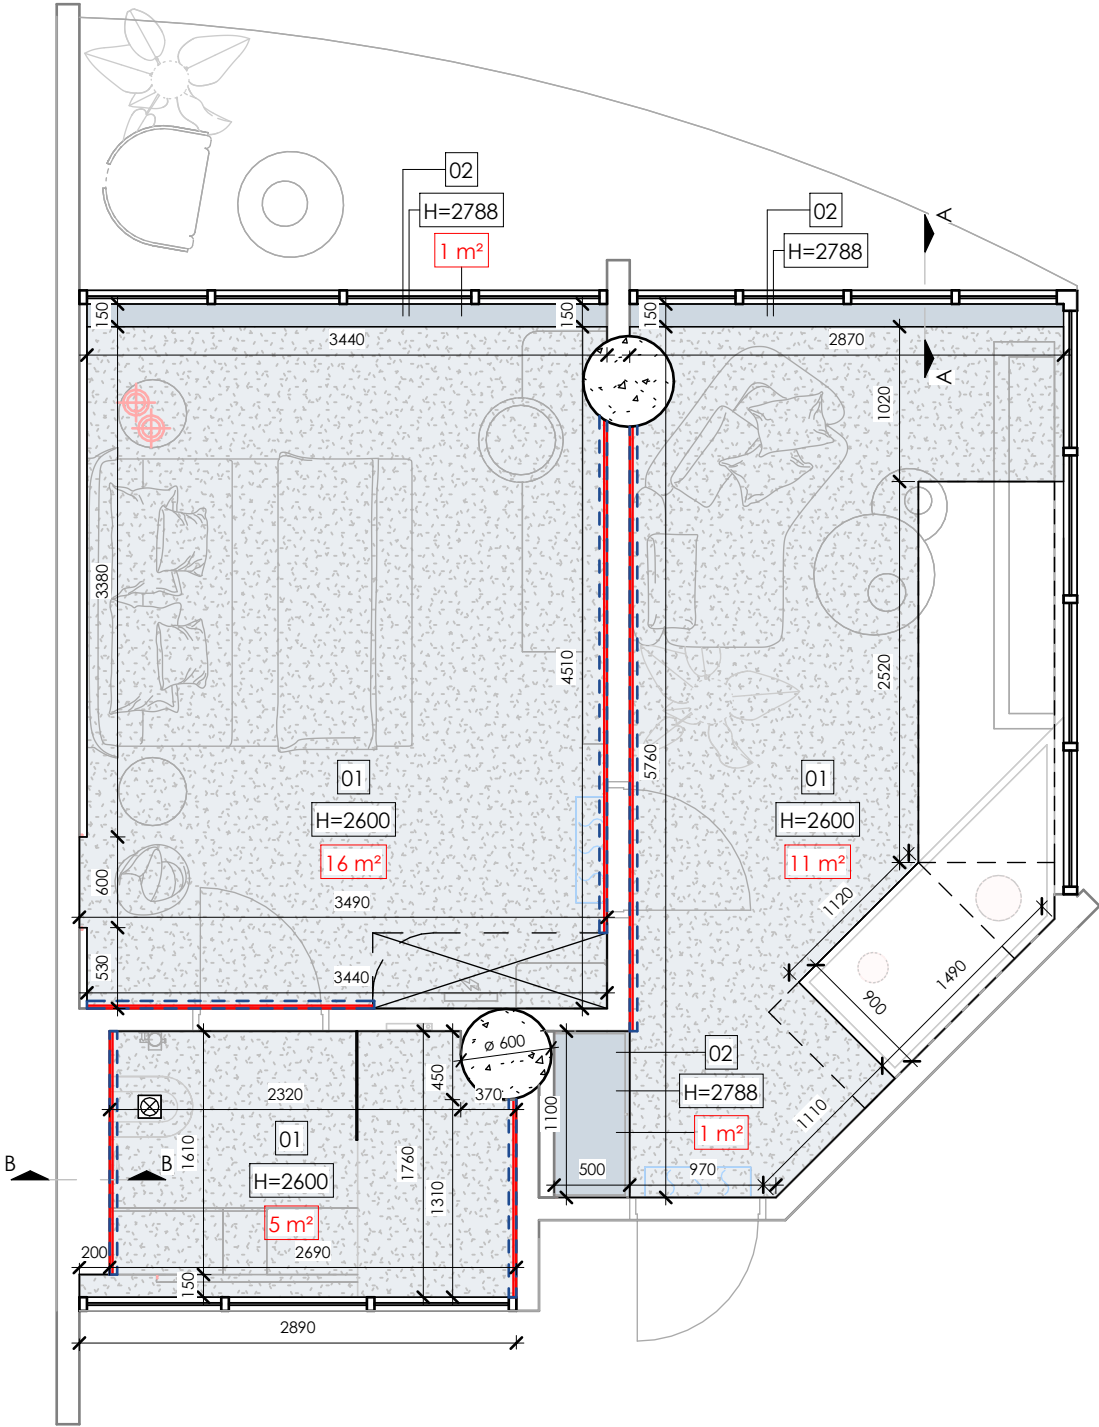

Ceiling Schedule


Mark	On the plan	Description	Area	Finish
01		Suspended ceiling. 1 drywall sheet 12.5mm on metal frame	31 m²	Plaster for painting
02		1 drywall sheet 12.5mm	1 m²	Plaster for painting

Total area: 33 m²


Shadow Seam Schedule

Mark	Appearance	Description	Length
SH-1		Aluminium shadow seam profile for LED line	12,195 mm

Section A-A

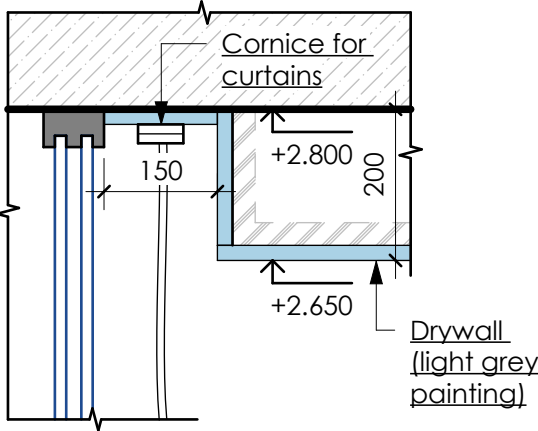

Section B-B

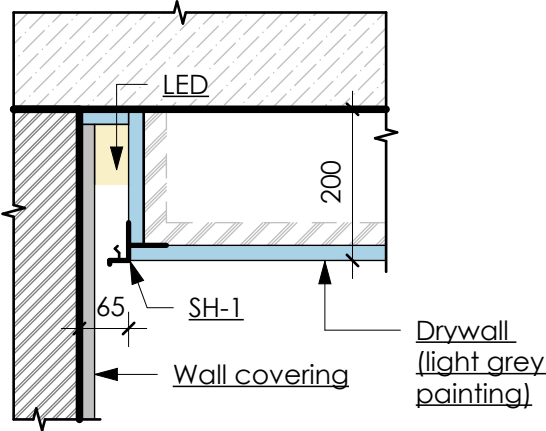

Legend :

- Ceiling LED
- Shadow seam
- Ceiling height offset from level

Notes:
1. Ceiling covering - plaster, painting. Coordinate the color with samples on the object with the designer

2. Areas are indicated without calculation for pruning and stock. Recommended margin - 15%

3. Important! In the place intended for blinds, provide for a cornice, model, dimensions and bindings to agree

4. Dimensions are indicated without plaster and wall decoration

MELASTI ARCADE

Sheet name
Ceiling finish plan


Scale
As indicated

Sheet
A107

SNAAR

Lighting

1 : 50

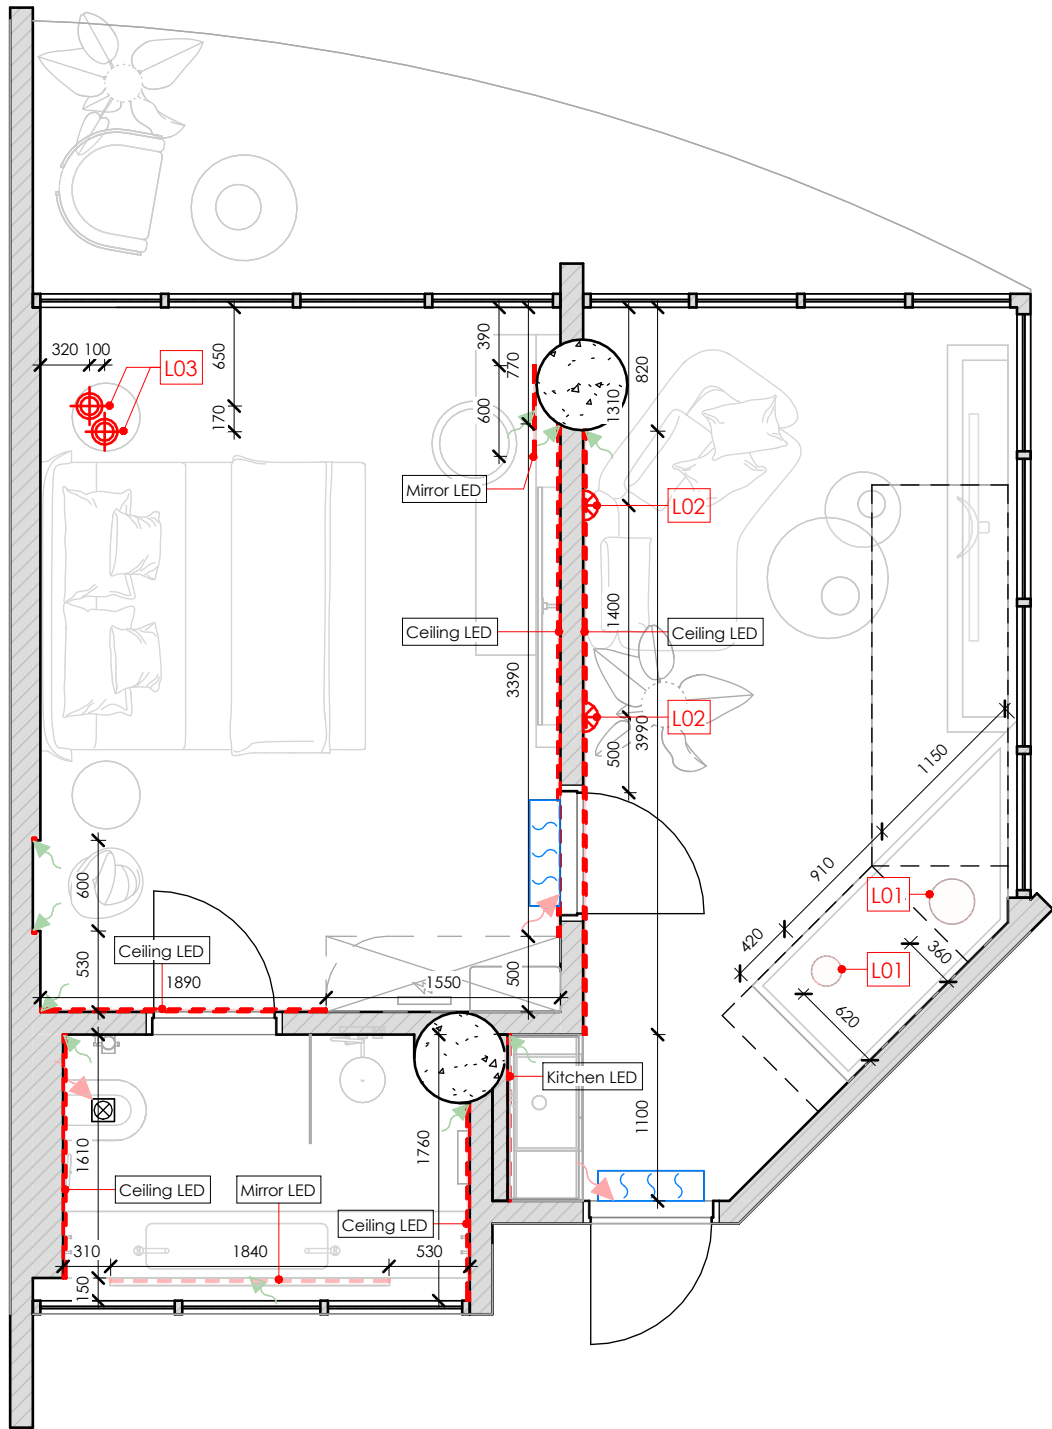

Lighting Fixture Schedule				
Mark	Description	Count	Symbol	Appearance
L01	Floor lamp, type 1	2		
L02	Sconce, type 1	2		
L03	Pendant light, type 1	2		

Grand total: 6

LED line Schedule	
Mark	Length
LED1	20,636 mm

Legend :

- LED line
- 220V wire output for LED line connection
- 12V wire output for LED line connection

- Notes:
1. Binding to lighting equipment is indicated in the center of the device
 2. Information about the heights of the lights and electrical outlets is on the "Wall elevations"
 3. The lengths are indicated without a margin
 4. The plan is considered together with the sheets "Ceiling finish plan", "Lighting groups plan"
 5. Dimensions marked with a "1st" are for approximate placement of the floor lamp elements. See the "wall elevation" sheet for clarification

MELASTI ARCADE

Sheet name

Lighting plan

Scale

As indicated


Sheet

A108

SNAAR

Light groups

1 : 50

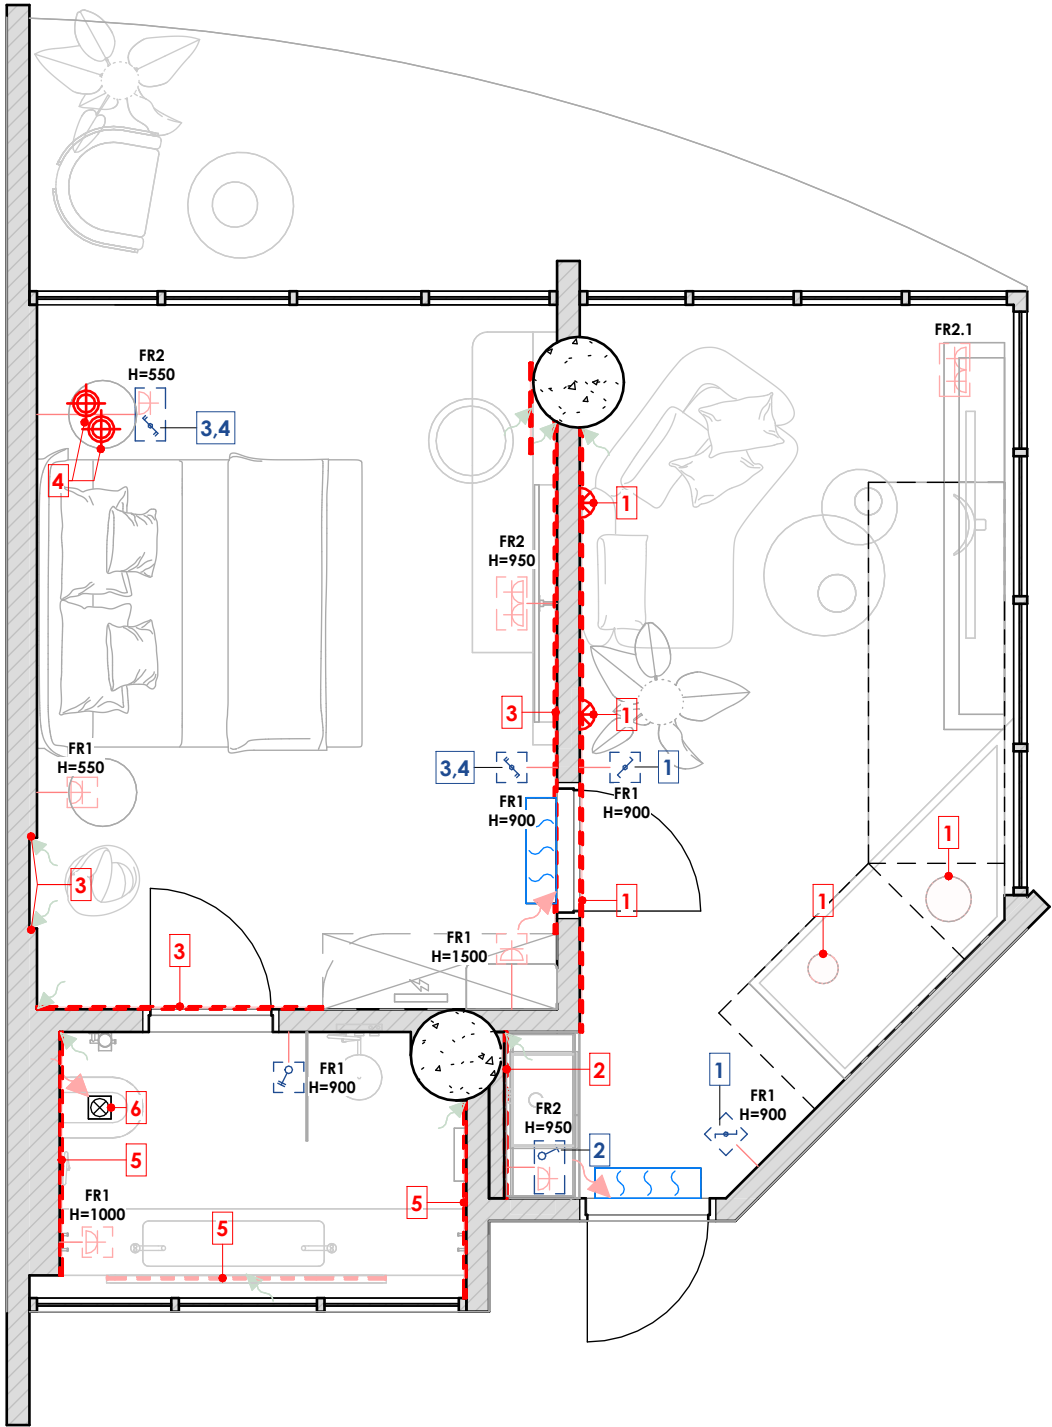

Electrical Frame Schedule

Mark	Count	Description	Installation type
FR1	7	Frame 1-post	Wall mounted
FR2	3	Frame 3-post	Wall mounted
FR2.1	1	Frame 2-post	Face mounted

Total: 11

- Notes:
1. The size is specified to the center of the element (both in height and in width)
 2. Read the diagram along with 'Lighting groups plan', and 'Electrical specification'

MELASTI ARCADE

Sheet name

Lighting groups plan

Scale

As indicated

Sheet

A109


SNAAR

Legend :

- LED line
- 220V wire output for LED line connection
- 12V wire output for LED line connection

Sockets & electrical output

1 : 50

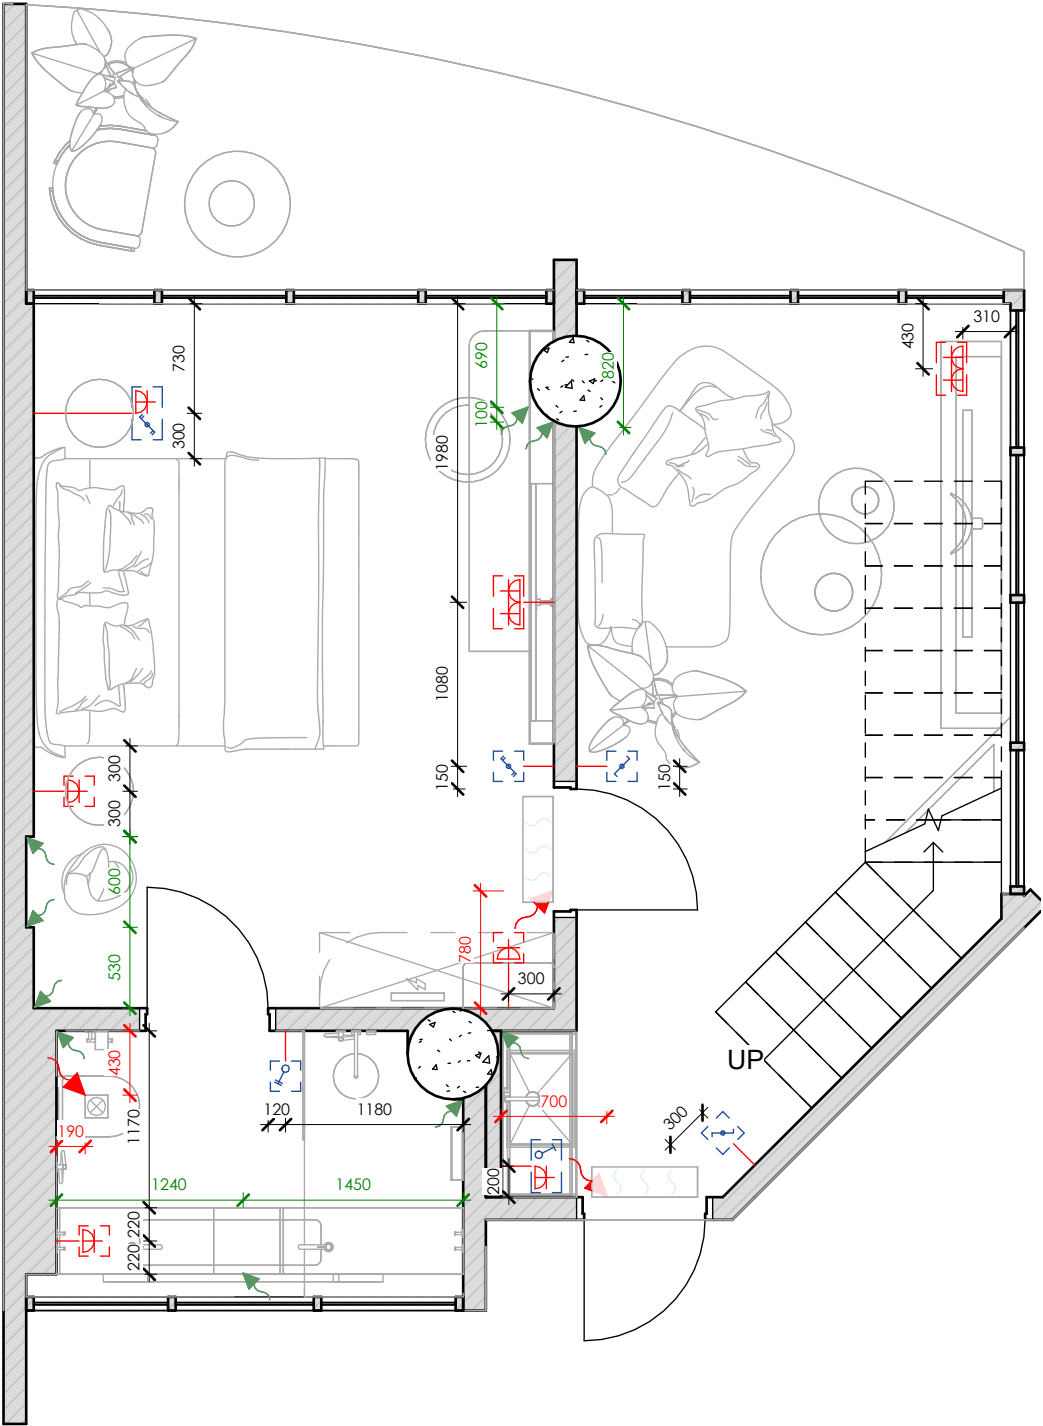

Socket/ Switch/ Output Schedule

Symbol	Count	Description
	1	One-key switch
	2	One-key through switch
	1	Two-key switch
	2	Two-key through switch
	10	12V Output
	9	220V Socket
	3	220V Output

Total: 28

Notes:
1. The size is specified to the center of the element (both in height and in width)

2. Read the diagram along with 'Lighting groups plan', and 'Electrical specification'

MELASTI ARCADE

Sheet name
Sockets & electrical
output layout


Scale
1 : 50

Sheet
A110

SNAAR

Wall finish

1 : 50

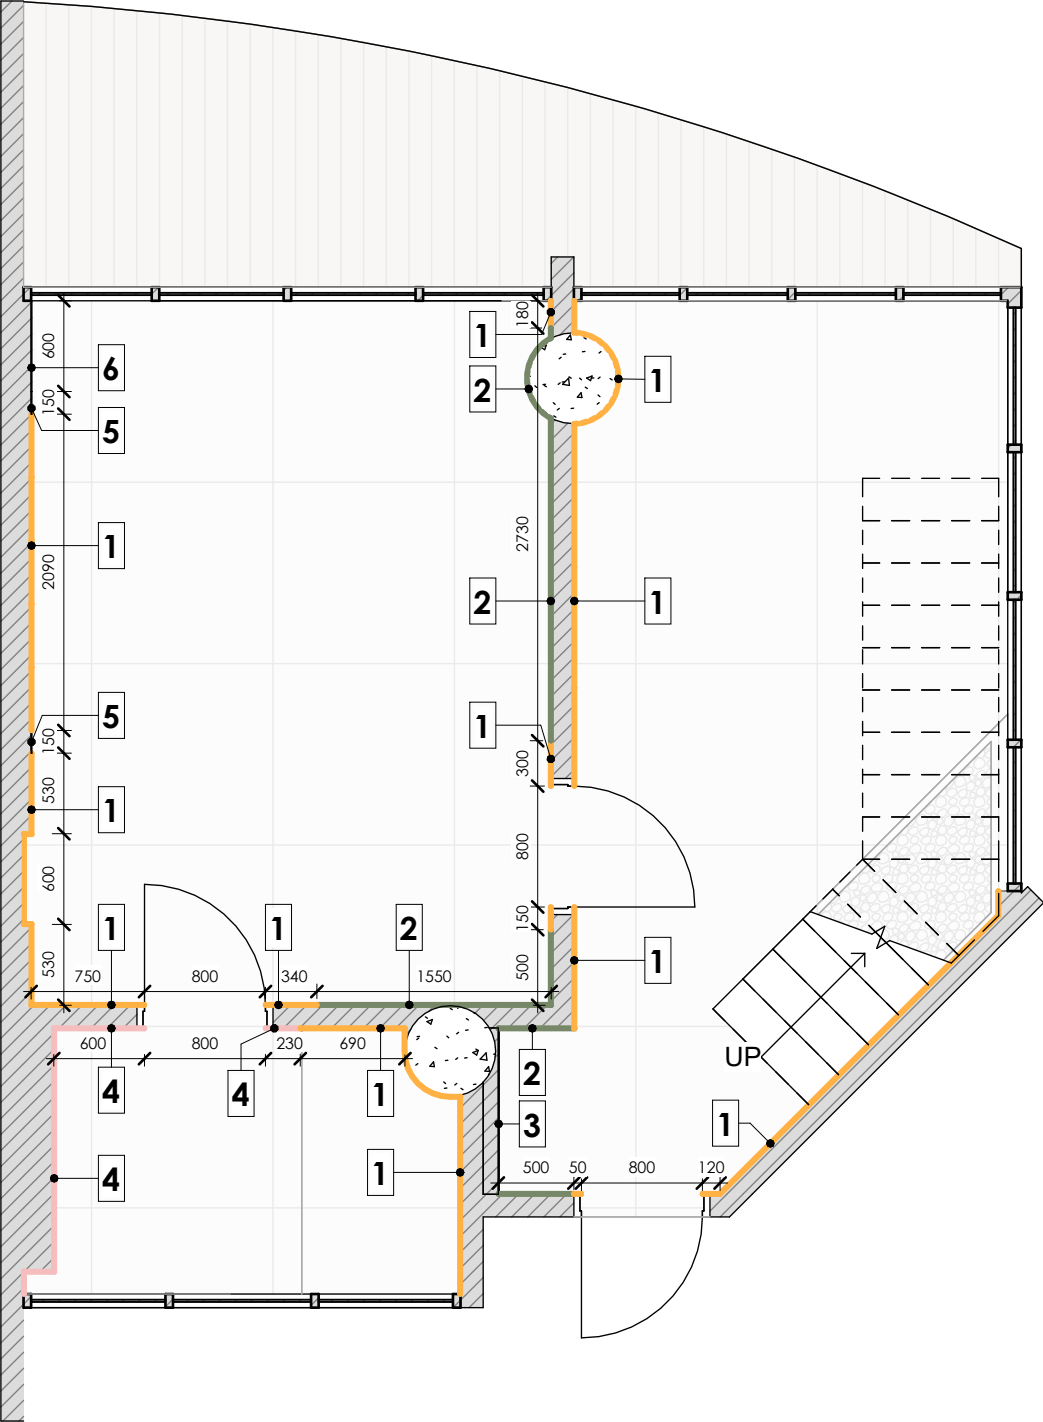

Wall Finish Schedule					
Mark	Description	On the plan	Pattern	Visualization	Area
1	Decorative plaster (grey)				47 m ²
2	Plaster without finishing (behind furniture)				14 m ²
3	Tile, type 1 (marble imitation)				1 m ²
4	Tile, type 2 (wood imitation)				8 m ²
5	MDF panel (bronze)				1 m ²
6	MDF panel (silver)				2 m ²

- Notes:
- 1. All sizes are specified on site
 - 2. Inform the architect about all discrepancies
 - 3. Check the sheet with the wall markings

MELASTI ARCADE

Sheet name

Wall finish plan

Scale

1 : 50


Sheet

A112

SNAAR

Marking

1 : 50

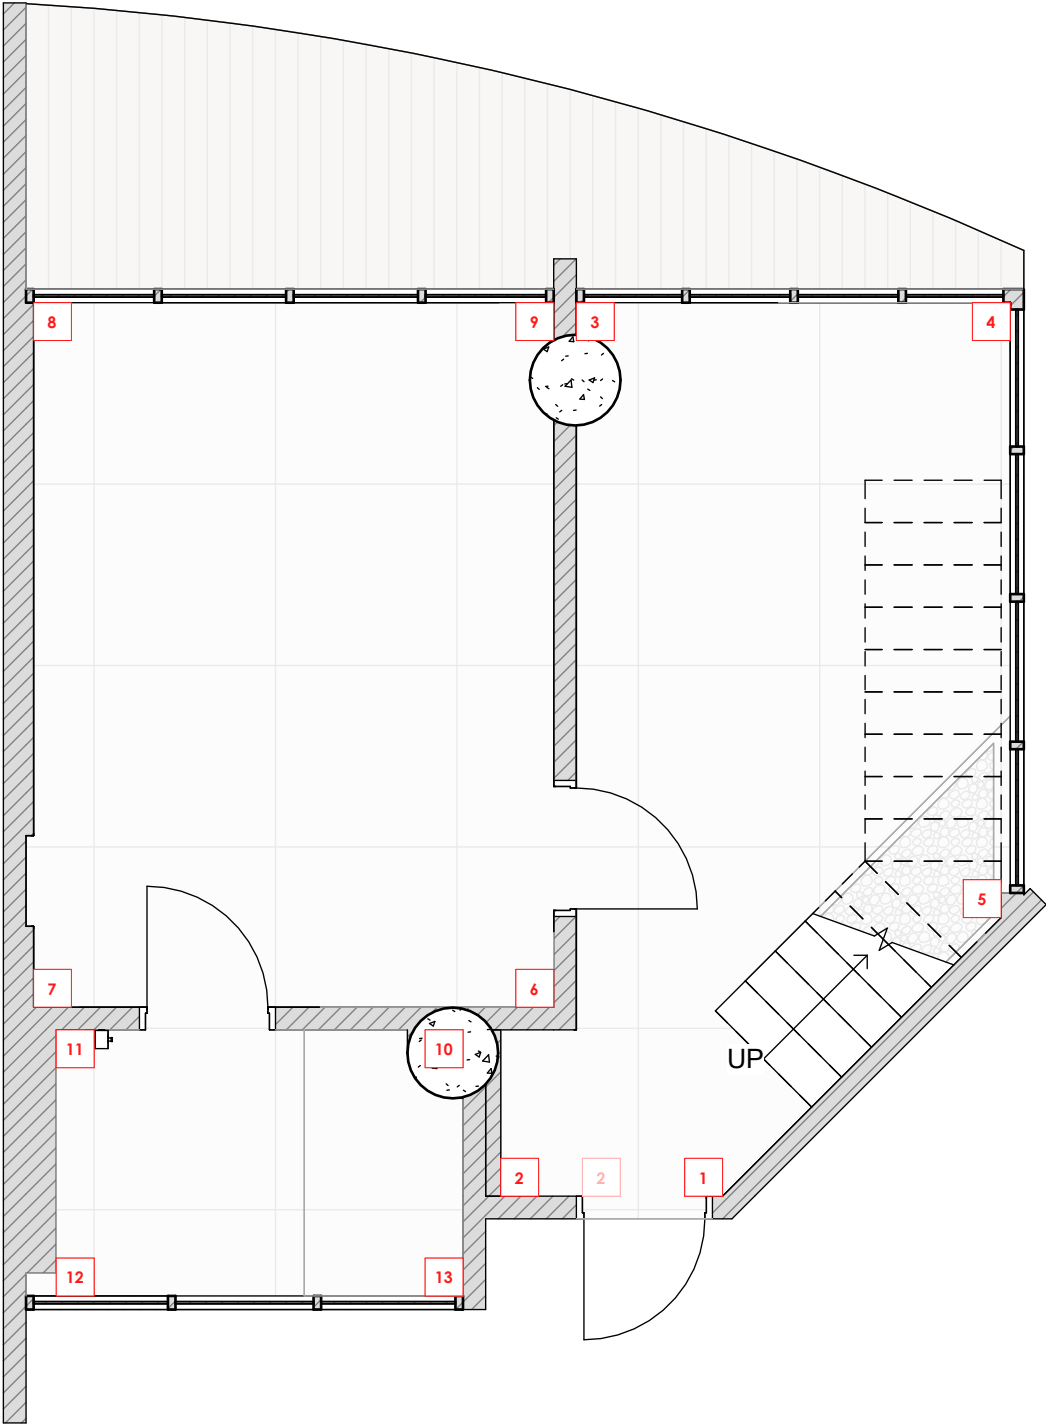

Notes:
1. Check the sheet
with the wall
markings

MELASTI ARCADE

Sheet name

Marking plan


Scale

1 : 50


Sheet

A113


SNAAR

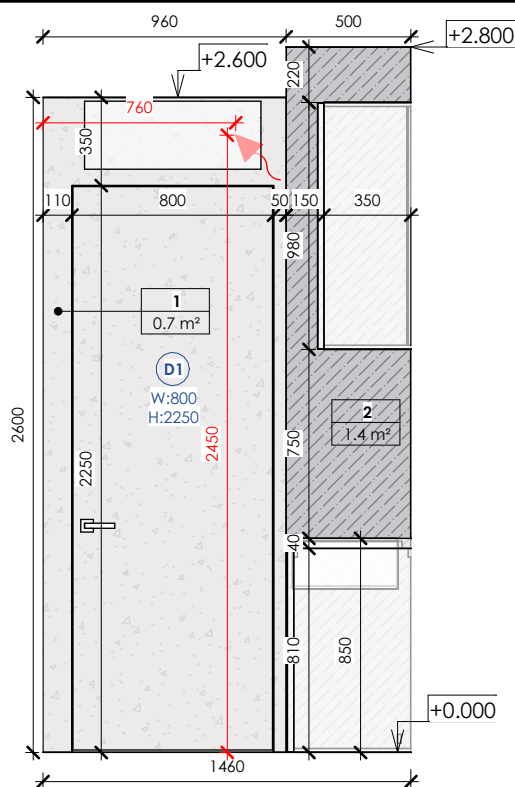


1-2

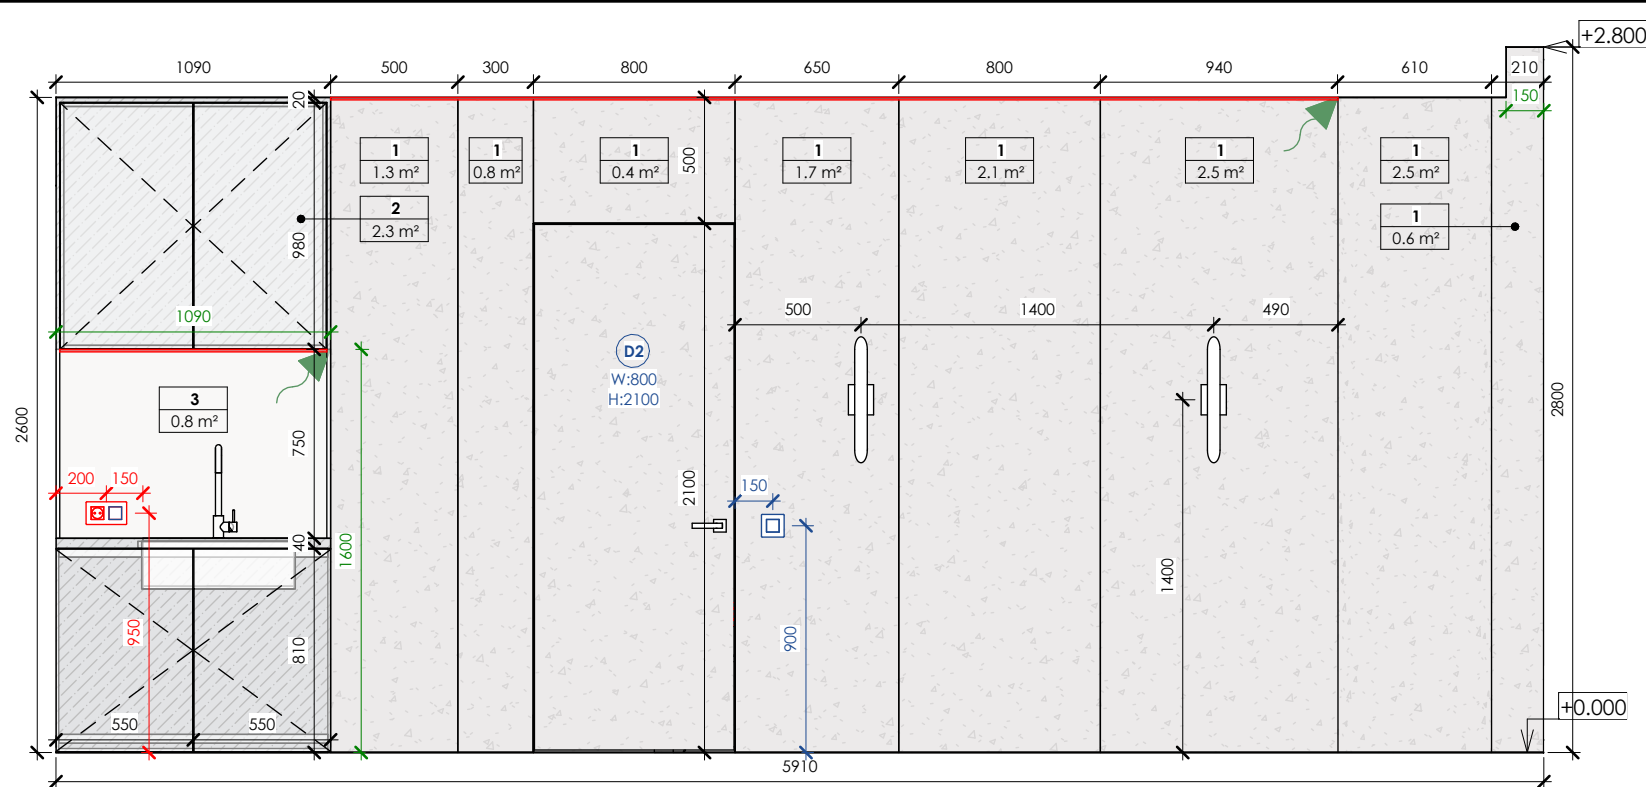


2-3

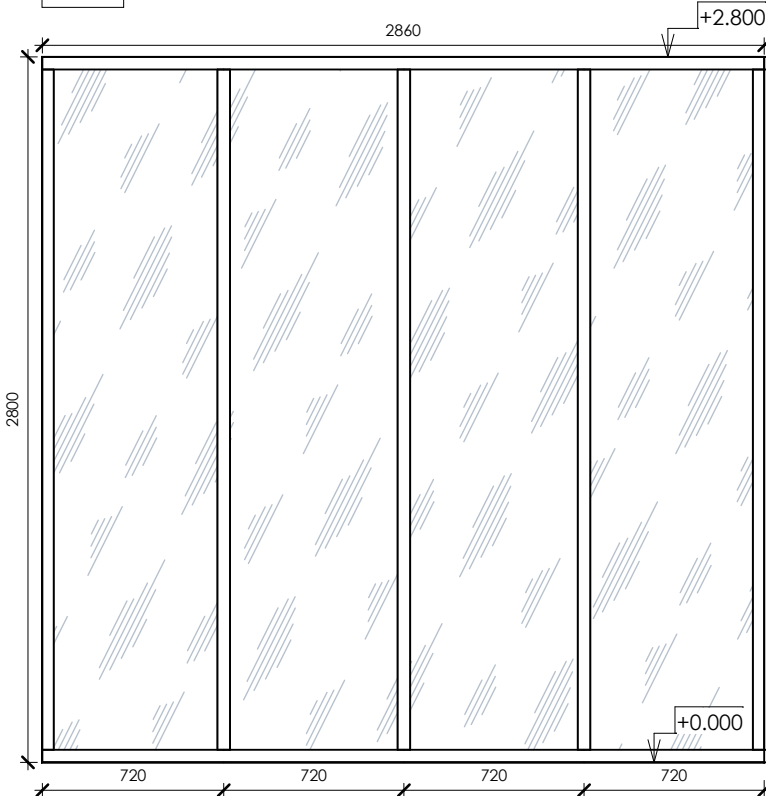

3-4

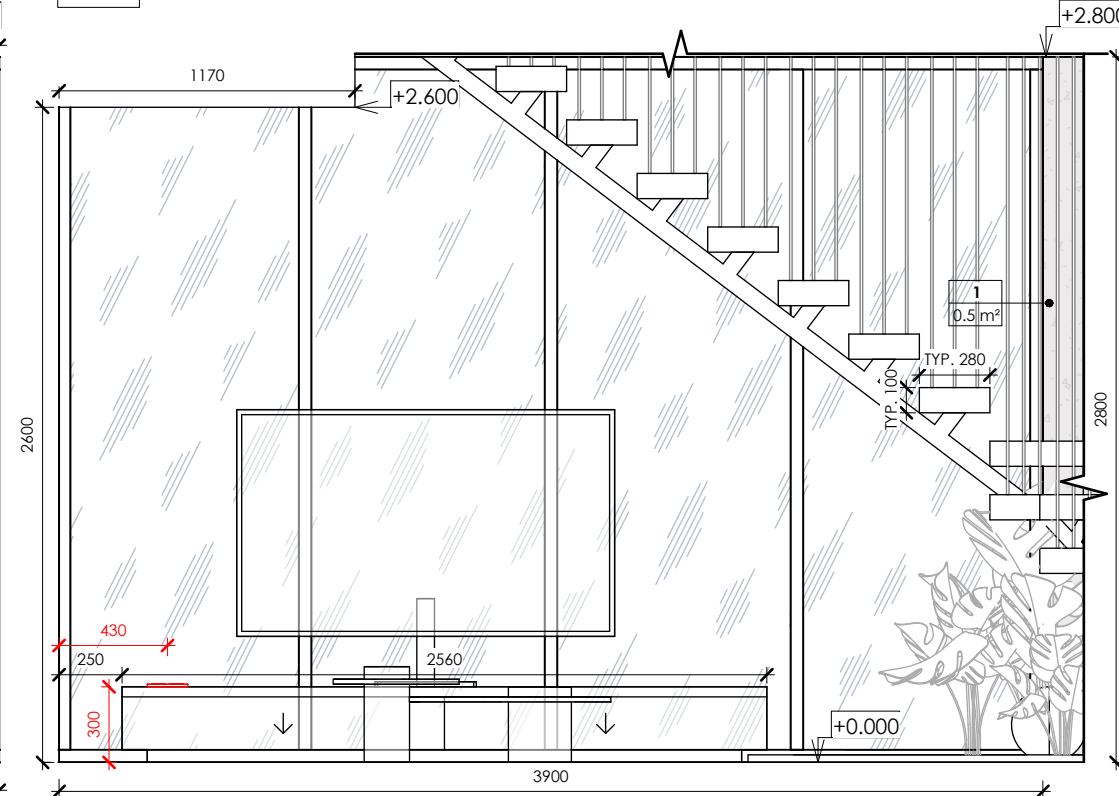

4-5

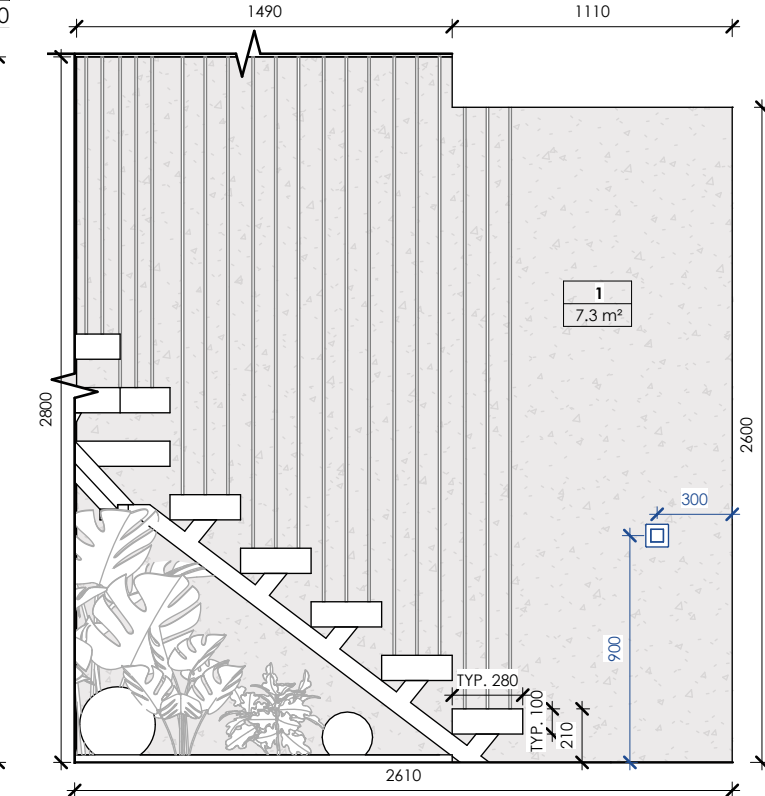

5-1

General Wall Finish Schedule			
Mark	Finish	Pattern	Total area
1	Decorative plaster (grey)		47 m²
2	Plaster without finishing (behind furniture)		14 m²
3	Tile, type 1 (marble imitation)		1 m²

General Wall Finish Schedule			
Mark	Finish	Pattern	Total area
4	Tile, type 2 (wood imitation)		8 m²
5	MDF panel (bronze)		1 m²
6	MDF panel (silver)		2 m²

- Notes:
1. All dimensions are to be specified on the spot
 2. Notify the architect of all discrepancies

Legend :

- LED line
- 220V wire output for LED
- 12V wire output for LED
- One-key switch
- One-key through switch
- Two-key switch
- Two-key through switch
- 220V socket

MELASTI ARCADE

Sheet name

Wall elevations


Scale

As indicated


Sheet

A114

SNAAR

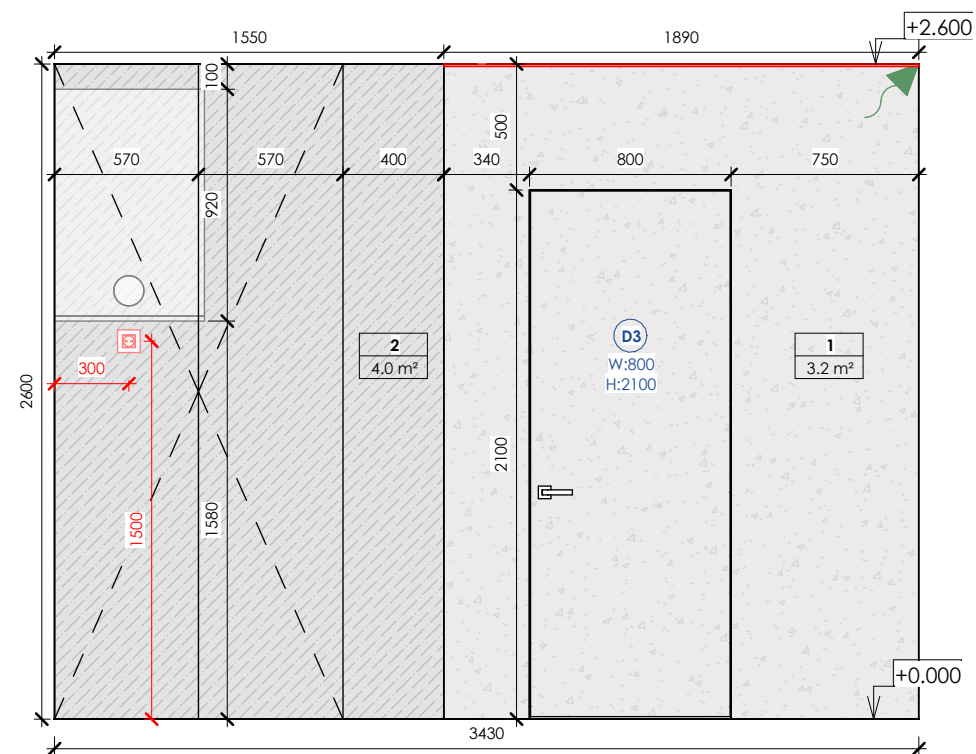


6-7

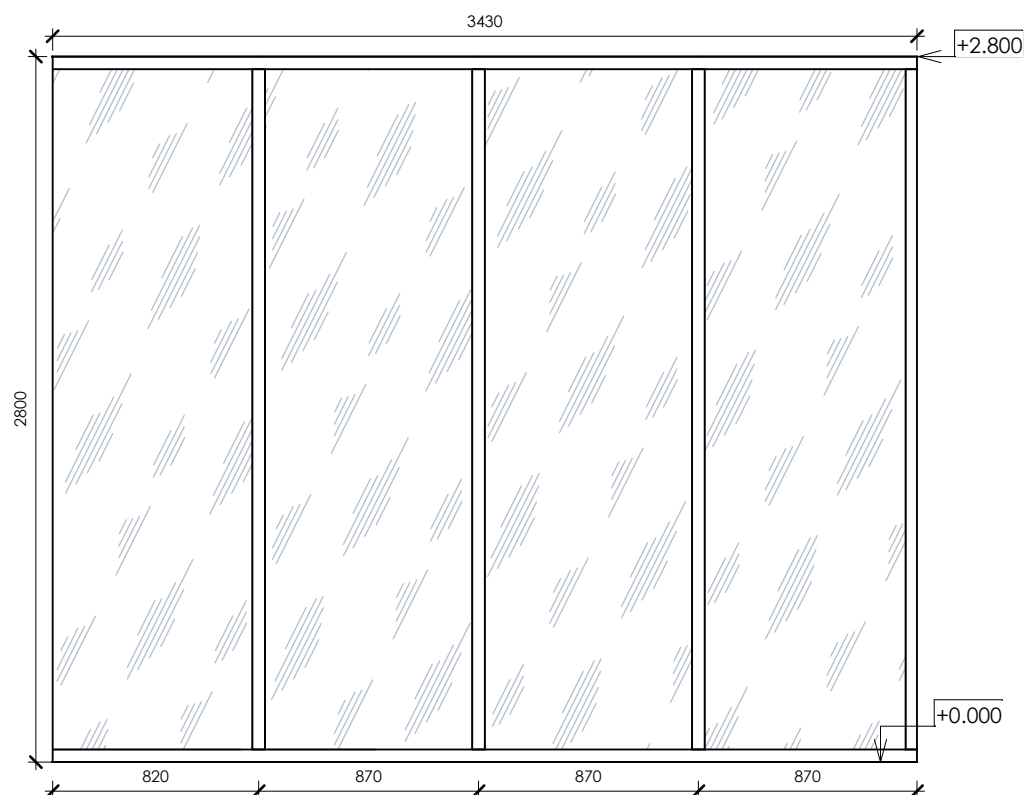


8-9

General Wall Finish Schedule			
Mark	Finish	Pattern	Total area
1	Decorative plaster (grey)		47 m ²
2	Plaster without finishing (behind furniture)		14 m ²
3	Tile, type 1 (marble imitation)		1 m ²

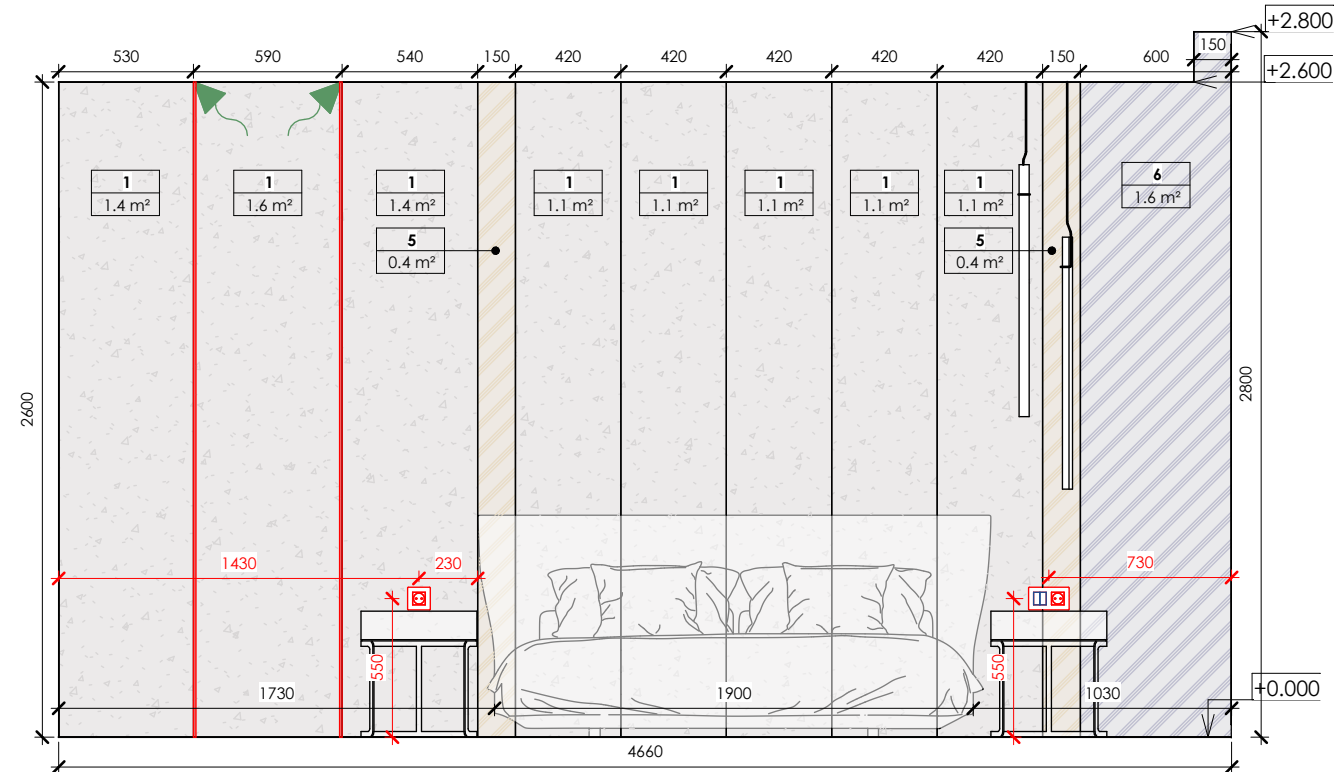

7-8

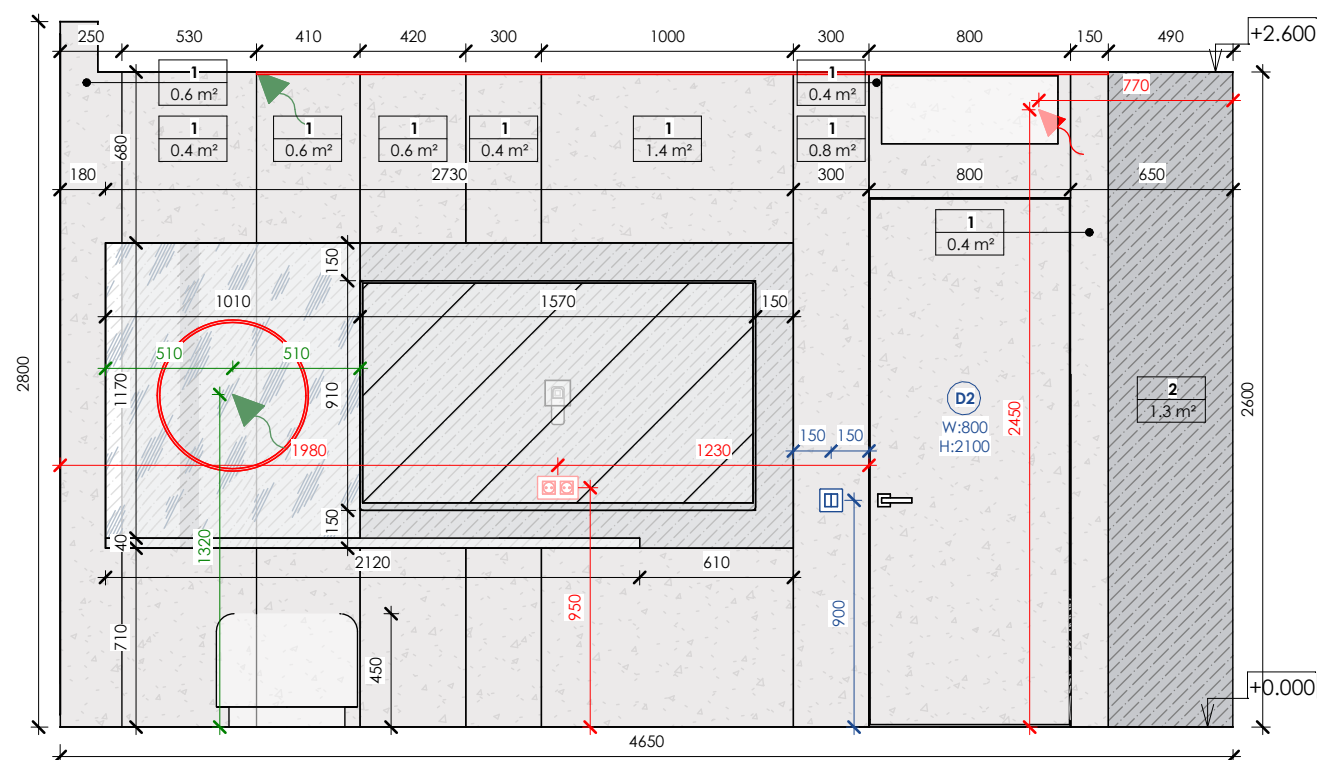

9-6

General Wall Finish Schedule			
Mark	Finish	Pattern	Total area
4	Tile, type 2 (wood imitation)		8 m ²
5	MDF panel (bronze)		1 m ²
6	MDF panel (silver)		2 m ²

Notes:

1. All dimensions are to be specified on the spot
2. Notify the architect of all discrepancies

Legend :

- LED line

220V wire output for LED

12V wire output for LED

One-key switch

One-key through switch

Two-key switch

Two-key through switch

220V socket

MELASTI ARCADE


Sheet name

Wall elevations


Scale
As indicated

Sheet
A115


SNAAR

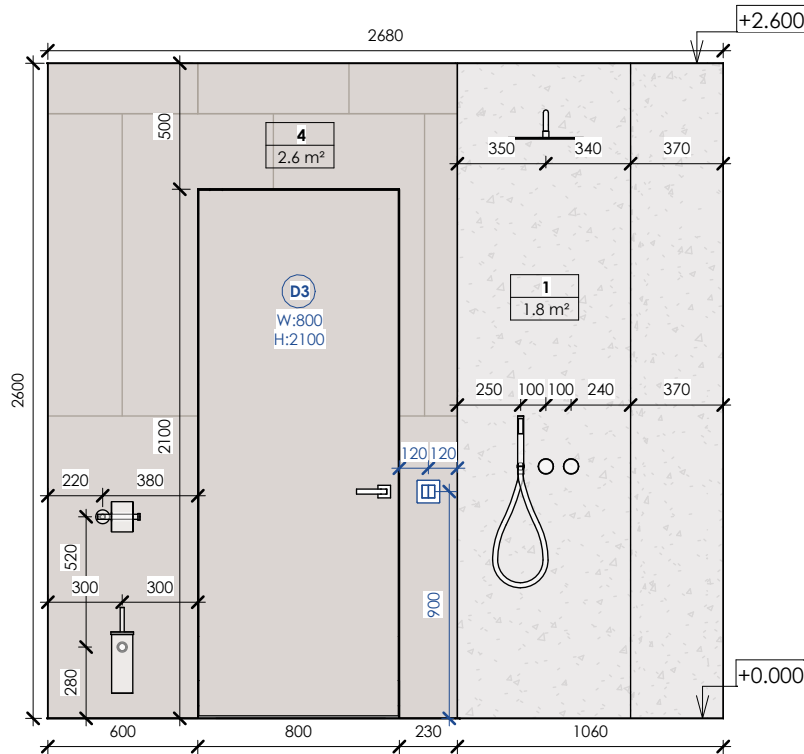


10-11

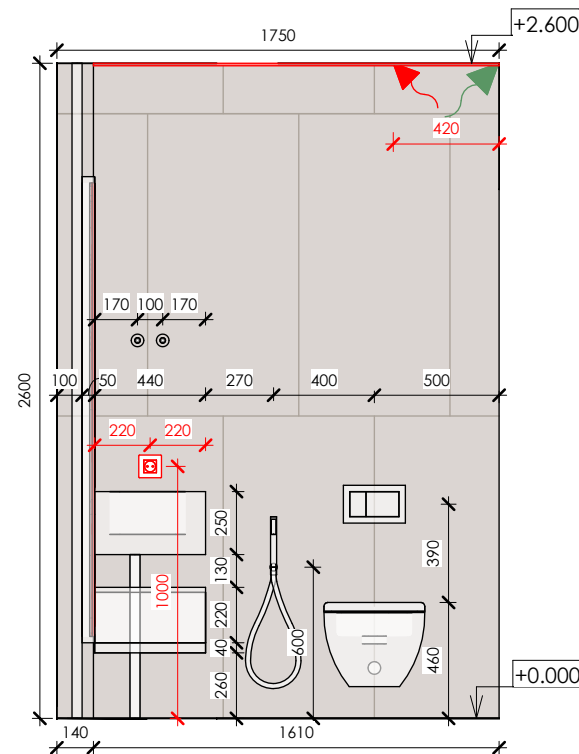

11-12

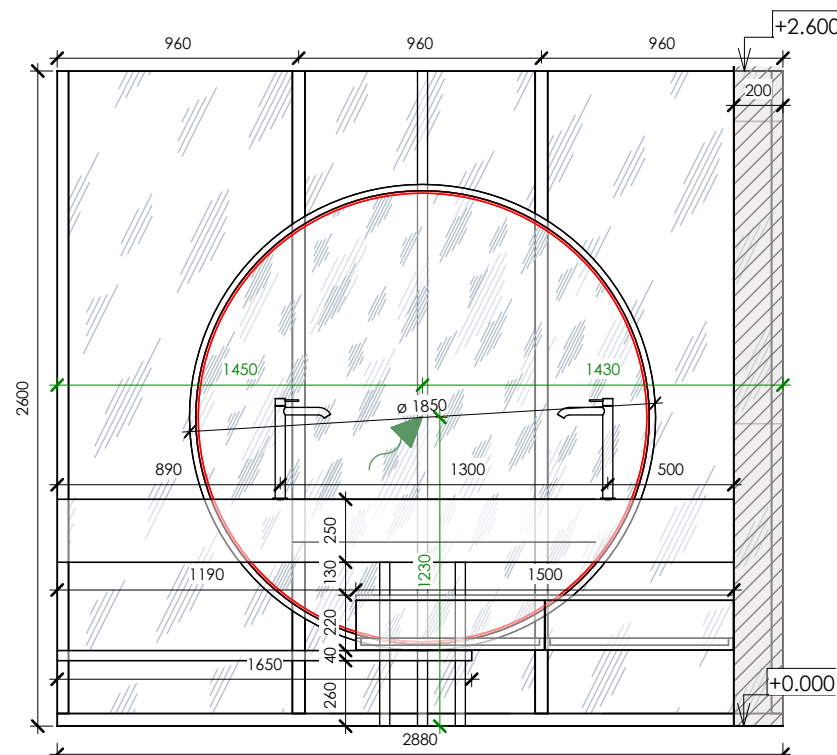

12-13

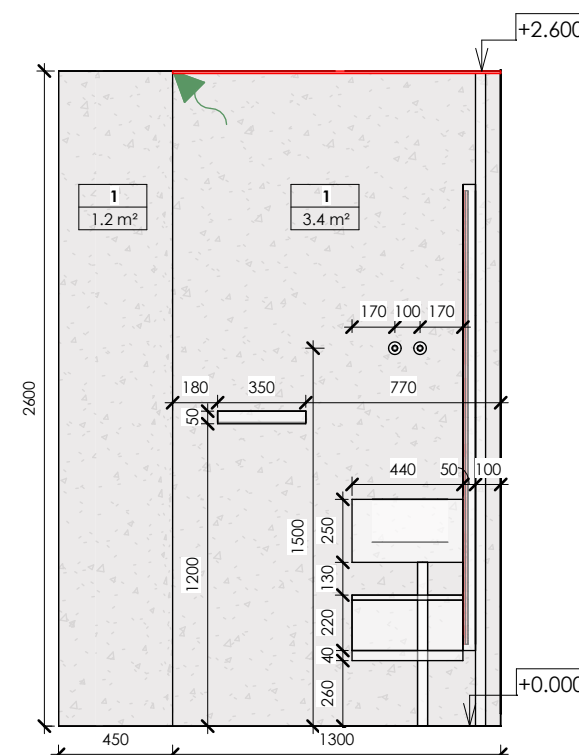

13-10

General Wall Finish Schedule			
Mark	Finish	Pattern	Total area
1	Decorative plaster (grey)		47 m²
2	Plaster without finishing (behind furniture)		14 m²
3	Tile, type 1 (marble imitation)		1 m²
4	Tile, type 2 (wood imitation)		8 m²
5	MDF panel (bronze)		1 m²
6	MDF panel (silver)		2 m²

Notes:
1. All dimensions are to be specified on the spot
2. Notify the architect of all discrepancies

Legend :

- LED line
- 220V wire output for LED
- 12V wire output for LED
- One-key switch
- One-key through switch
- Two-key switch
- Two-key through switch
- 220V socket

MELASTI ARCADE

 
 

Sheet name

Wall elevations

Scale
As indicated

Sheet
A116

SNAAR

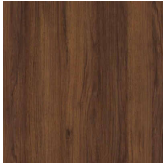Material Takeoff					
Material Name	Image	Manufacturer	Notes	Product Link	Area
Decorative plaster (grey)		CERESIT	CT 35 MAJORCA 1MJ1	https://ceresit.ua/ru/catalog/uteplennya-fasadiv/ceresit-ct-35.html	49 m²
Glass, type 1		Local market			4 m²
Mirror, type 1		Local market			8 m²
Patio board (light wood)		Local market			9 m²
Plaster for painting		Local market	RAL 9010		33 m²
Plaster without finishing (behind furniture)		Local market	RAL 9003		14 m²
Tile type 1 (grey)		Marvel Grey Stone	1200x1200mm	https://www.atlasconcorde.com/en/ac-collection/marvel/grey-stone	36 m²
Tile type 2 (wood imitation)		Atlas Concorde Entice Copper Oak Natural	1200x600mm	https://www.atlasconcorde.com/en/ac-collection/entice	8 m²

MELASTI ARCADE

Sheet name

Specifications





Scale

Sheet

A117

SNAAR

Lighting Fixture Specification						
Symbol	Product Name	Manufacturer	Product Code	Product Photo	Product Link	Count
	LED	Philips	Philips Hue LightStrips Plus		https://www.philips-hue.com/en-us/p/hue-white-and-color-ambi	10
	Pendant light, type 1	VIBIA	Halo jewel		https://vibia.com/en/int/collections/hanging-lamps-halo-jewel-hanging	2
	Sconce, type 1	Regina Andrew	Redford Sconce		https://www.reginaandrew.com/Redford-Sconce?quantity=1&custcolfinishmatrix=1&custcol_bulb_item=35042&custcol_bulb_qty=2&srltid=AfmBOoqHYMmcf4dOixZ803hcpy9x2-Sqvha8iQDQ6nCpnFfRfFNi1nbJ	2
	Floor lamp	PK Green	Ball Floor Lamp		https://www.pkgreenshop.co.uk/products/40cm-glowing-sphere-light-event-wedding-led-lighting-warm-white?currency=GBP&utm_source=google&utm_medium=cpc&utm_campaign=Google%20Shopping&stkn=bb2c80bf1dbe	2

    Electrical Specification						
Symbol	Product Name	Manufacturer	Product Code	Product Photo	Product Link	Count
	Frame 1-post	Schneider Electric	EPH5800171		https://elektronik.kiev.ua/index.php/shop/rostki-i-vik-2/rozetki-i-vik-schneider/schnaider-asfora/asfora-ant ratsit/ramka-schneider-shnajder-asfora-plus-1-post-gorizontalnaya-antratsit	7
	Frame 2-post	Schneider Electric	EPH5800271		https://elektronik.kiev.ua/index.php/shop/rostki-i-vik-2/rozetki-i-vik-schneider/schnaider-asfora/asfora-ant ratsit/ramka-schneider-shnajder-asfora-plus-2-postovaya-gorizontalnaya-antratsit	4
	Two-key through switch	Schneider Electric	EPH0300171		https://elektronik.kiev.ua/index.php/shop/rostki-i-vik-2/rozetki-i-vik-schneider/schnaider-asfora/asfora-ant ratsit/pereklyu chatel-schneider-shnajder-asfora-plus-2-klavishnyj-prokhodnoj-antratsit	2
	220V Socket	Schneider Electric	EPH2900171		https://elektronik.kiev.ua/index.php/shop/rostki-i-vik-2/rozetki-i-vik-schneider/schnaider-asfora/asfora-ant ratsit/rozetka-schneider-shnajder-asfora-plus-s-zazemleniem-antratsit	9
	Two-key switch	Schneider Electric	EPH0300171		https://elektronik.kiev.ua/index.php/shop/rostki-i-vik-2/rozetki-i-vik-schneider/schnaider-asfora/asfora-ant ratsit/pereklyu chatel-schneider-shnajder-asfora-plus-2-klavishnyj-prokhodnoj-antratsit	1
	One-key switch	Schneider Electric	EPH0100171		https://elektronik.kiev.ua/index.php/shop/rostki-i-vik-2/rozetki-i-vik-schneider/schnaider-asfora/asfora-ant ratsit/vyklyuch atel-schneider-shnajder-asfora-plus-1-klavishnyj-antratsit	1
	One-key through switch	Schneider Electric	EPH0100171		https://elektronik.kiev.ua/index.php/shop/rostki-i-vik-2/rozetki-i-vik-schneider/schnaider-asfora/asfora-ant ratsit/vyklyuch atel-schneider-shnajder-asfora-plus-1-klavishnyj-antratsit	2

MELASTI ARCADE

Sheet name

 
 

Specifications

Scale

Sheet

A118

SNAAR

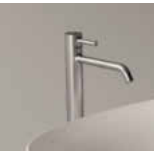General Specification						
Product Name	Manufacturer	Product Code	Dimensions	Product Photo	Product Link	Count
Air conditioner	LG	LG PC24SQ	W: 820 D: 200 H: 270mm		https://www.lg.com/ua/aircon/lg-pc24sq	2
Armchair	Minotti	Halley "Outdoor"	W: 650 D: 800 H: 420mm		https://www.minotti.com/en/halley-outdoor_2	1
Bed	B&B	Alys	W: 1900 L: 2150 H: 890mm		https://www.bebitalia.com/en-us/en-alys-letti.html	1
Bedside table	Deveno	Mut	D(W): 450 H: 500mm		https://deveno.ru/mebel/tumbi/tumba-mut-by-deveno	2
Boiler	Bosch	Tronic 3500	W: 600 D: 300 H: 920mm		https://bosch-centre.com.ua/ploskyi-elektrychnyi-boiler-bosch-tronic-3500-tr3501-100-ebp-7736507294	1
Coffee table, type 1	Gallotti&Radice	Haumea	D(W): 800 H: 300mm		https://www.gallottiradice.it/en-us/products/haumea	1
Coffee table, type 2	Gallotti&Radice	Haumea	D(W): 500 H: 380mm		https://www.gallottiradice.it/en-us/products/haumea	1
Coffee table, type 3	Molteni	Louisa	D(W): 700* H: 280mm		https://www.molteni.it/en/product/louisa	1
Commode	Custom		W: 2600 D: 400 H: 300mm			1
Exhaust fan	Ergovent	Rondo	Diameter: 150mm		https://www.ergovent.co.uk/	1
Faucet	Aliceceramica	22440101	H: 360*mm		https://www.aliceceramica.com/en/collezioni/form-washbasin-oval-60x35-h15/	2
Glass panel	Custom		W: 720 H: 2600mm			1
Hygienic shower	Gessi	Gessi 316 Set Douche	Connection diameter: 60mm		https://dwellistore.fr/gessi-316-ensemble-douche-54023.html?srsItid=AfmBOoqAy2_yHcq2LuLdhdBENtinHxQDVy58sAwRgPhgrtyyD0rnN-PwdP8	2

MELASTI ARCADE


Sheet name
Specifications

Scale

Sheet
A119

SNAAR

General Specification

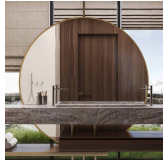Product Name	Manufacturer	Product Code	Dimensions	Product Photo	Product Link	Count
Mirror, type 1	Custom		W: 1010 H: 1170mm			1
Mirror, type 2	Custom		Diameter: 1850mm			1
Mixer	Gessi	Gessi316 54019299	Diameter: 60mm		https://budcamp.com.ua/products/zmishuvach-dlya-vanni-gessi-gessi316-54019299	2
Poof	Porada	Smile	D(W): 600* H: 450mm		https://www.porada.it/ru/%D0%B8%D0%B7%D0%B4%D0%B5%D0%BB%D0%B8%D0%B5/smile/	1
Shower head	Gessi	Gessi316 (54148-239)	Diameter: 300mm		https://home-fashion.com.ua/verkhniy-dush-gessi-316-shower-54148-239/	1
Sink	Blanco	Etagon	W: 600 D: 400 H: 200mm		https://www.blanco.co.uk/sinks/etagon/blancoetagon500-uinfino_232.752/52775	1
Sink mixer	Gessi	Stelo 60315			https://www.gessi.com/en/kitchen/stelo	1
Sofa	Poliform	SAINT-GERMAIN	W: 1990* D: 1200* H: 400*mm		https://www.poliform.it/en/products/saint-germain/	1
Toilet	NIC	VASO SOSPESO SEMPLICE RIMLESS cod. 003 699	W: 400 D: 550 H: 330mm		https://www.nicdesign.it/it/arredo-bagno/sanitari-wc-bidet/wc-e-bidet-sospesi/semplice-wc-e-bidet-sospesi_18.htm	1
TV 65"	LG	65QNED80UQA	Diagonal 65"		https://www.lg.com/us/tvs/lg-65qned80uqa-qned-4k-tv	2
TV cabinet	Custom		W: 2730 D: 160 H: 1210mm			1

MELASTI ARCADE

Sheet name

Specifications

Scale

Sheet

A120

SNAAR